


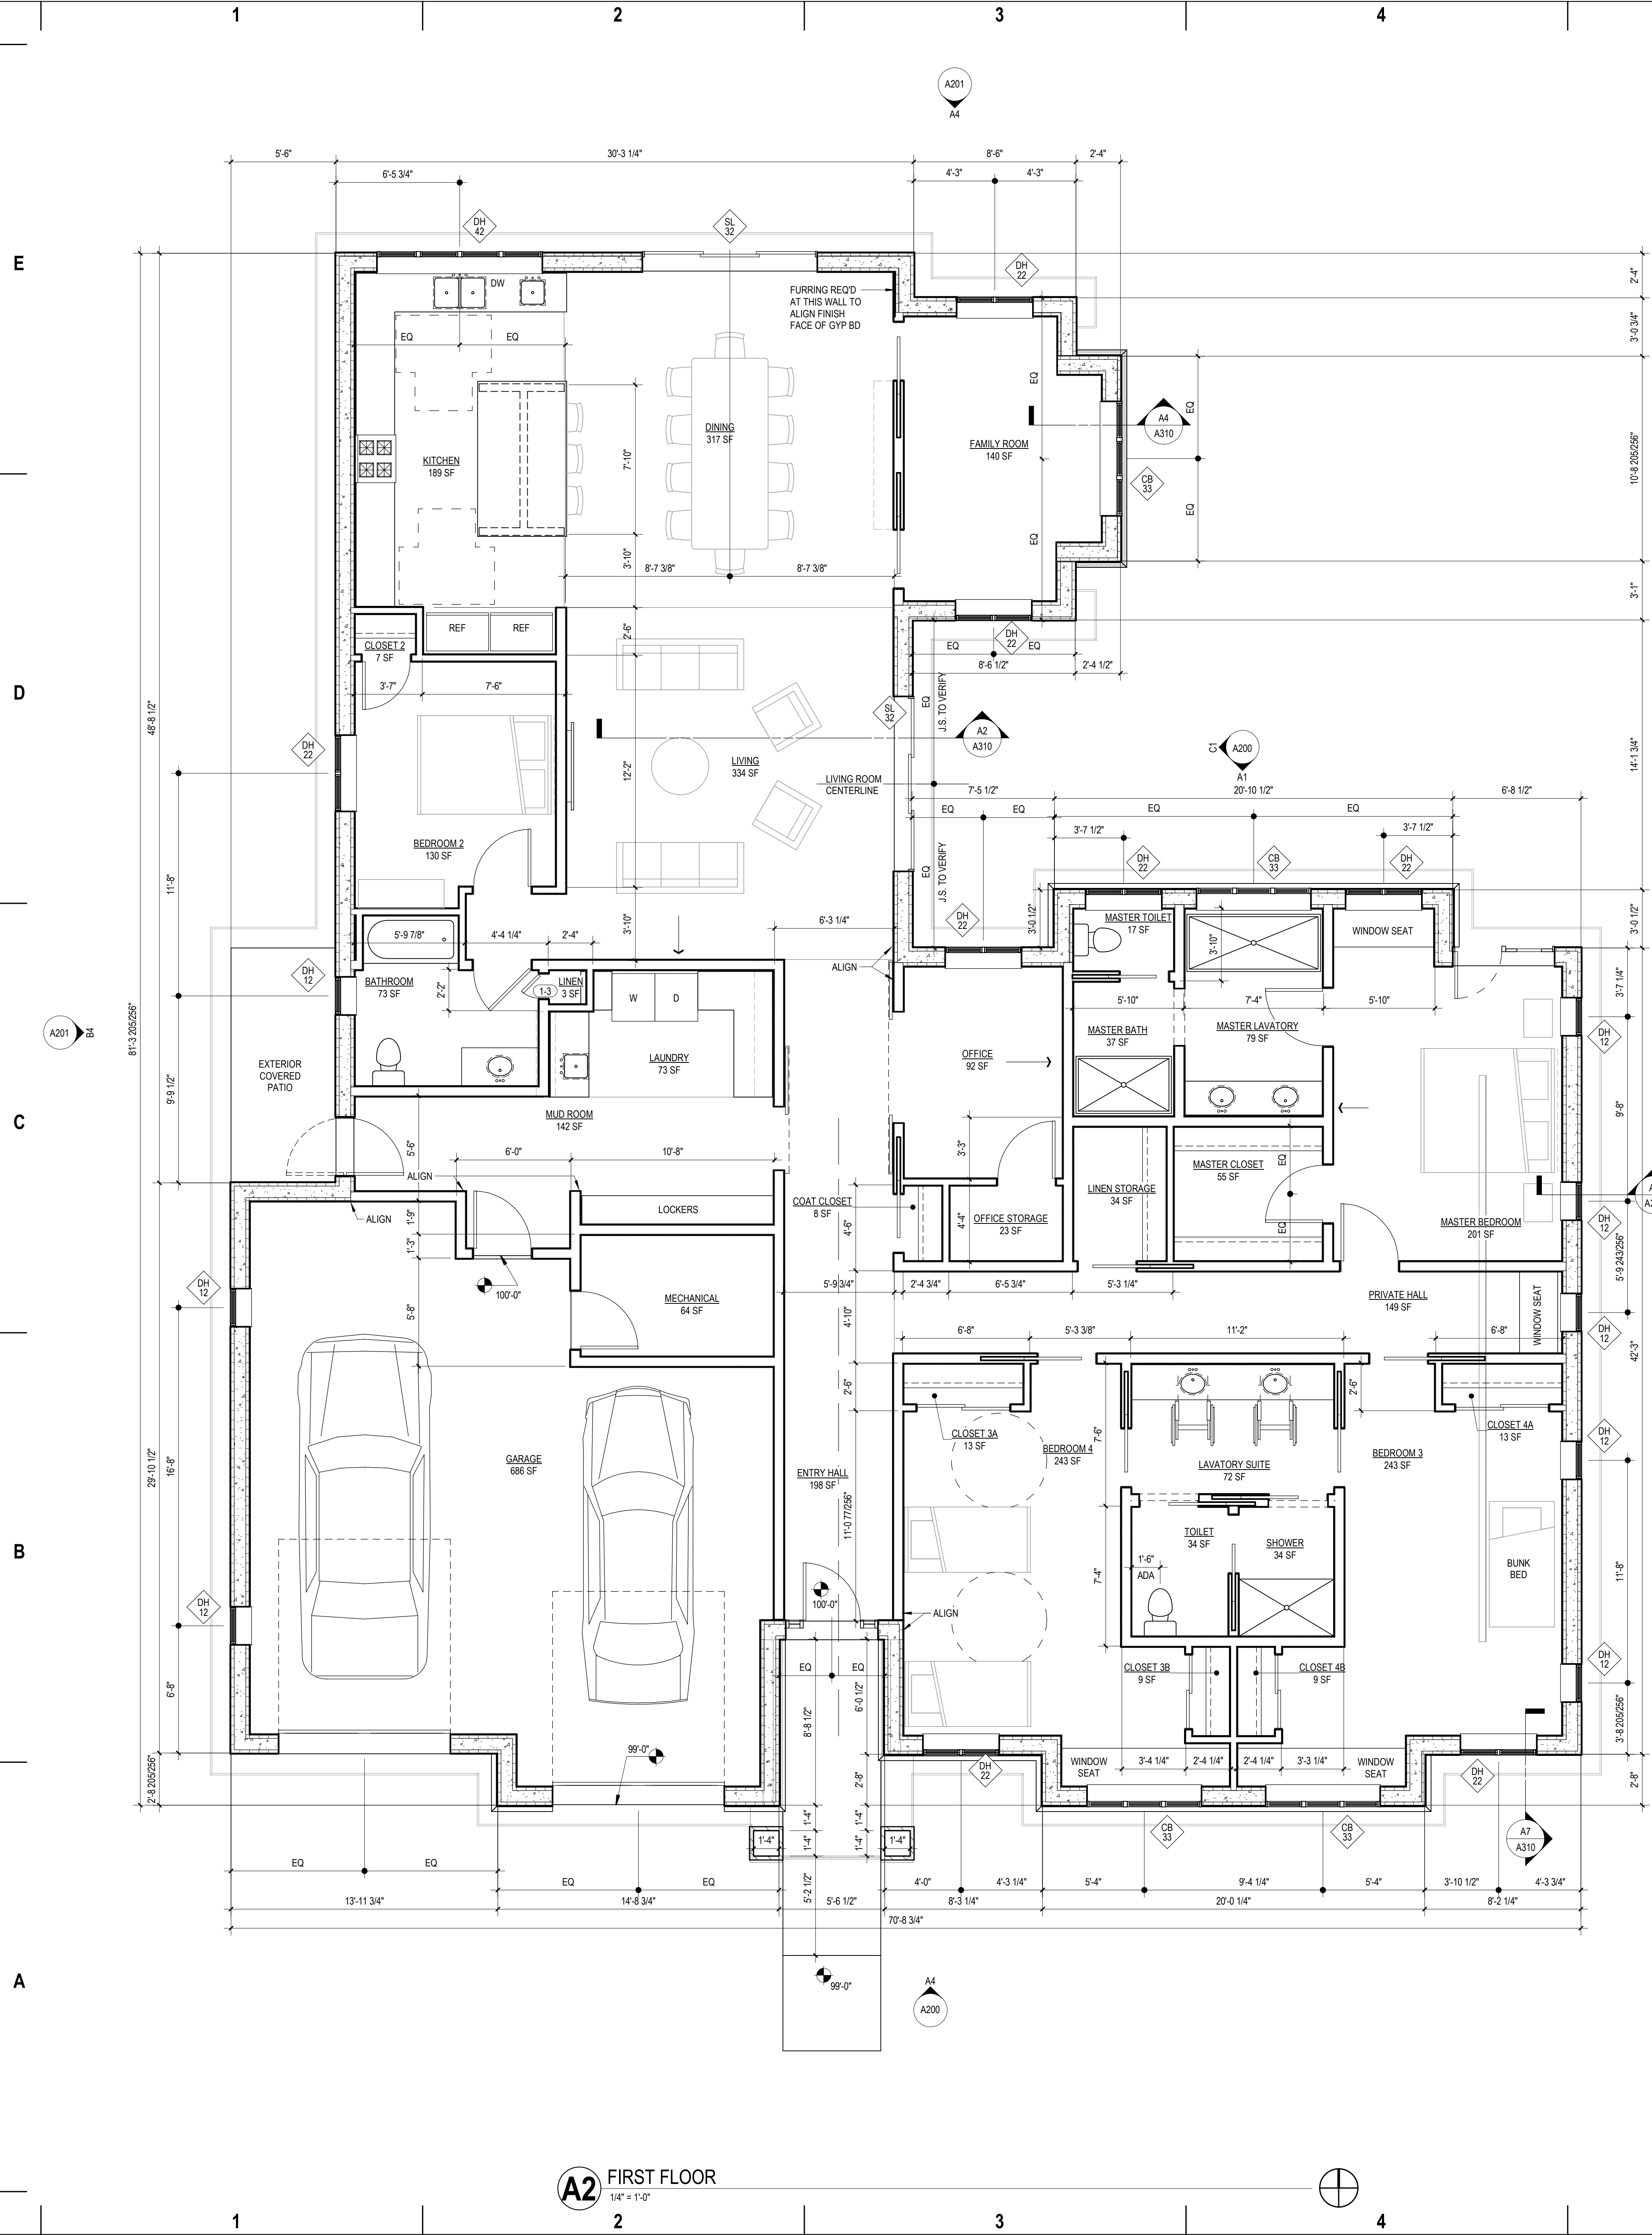

SHEET NOTES - FLOOR PLAN

- ALL EXTERIOR ICF WALLS ARE DIMENSIONED TO EXTERIOR FACE OF BOARD INSULATION UNLESS NOTED OTHERWISE.
- ALL INTERIOR WOOD STUD WALLS ARE DIMENSIONED TO FACE OF STUD. ALL EXTERIOR WOOD WALLS AND RAFTER FRAMED WALLS ARE DIMENSIONED TO OUTSIDE FACE OF SHEATHING, WHICH IS FIGURED TO BE 1/2" SHEATHING (STRUCTURAL ENGINEERING BY OTHERS).
- PROVIDE BLOCKING WITHIN INTERIOR WALLS TO SUPPORT WALL MOUNTED ACCESSORIES INCLUDING BUT NOT LIMITED TO CASEWORK, COUNTERTOPS, TOWEL BARS, TOILET PAPER DISPENSERS, CLOSET SHELVING, AND WINDOW SEAT CASEWORK.
- ALL DOORS ARE 3'-0" DOORS UNLESS NOTED OTHERWISE.
- PROVIDE MOISTURE RESISTANT AND MILDREW RESISTANT TYPE GYPSUM BOARD AT PLUMBING FIXTURE WALLS.
- PROVIDE REQUIRED UTILITY SERVICES TO EQUIPMENT, FURNISHINGS AND APPLIANCES.
- PROVIDE MOISTURE RESISTANT AND MOLD RESISTANT GYPSUM BOARD AT PLUMBING FIXTURE WALLS.
- LOCATE ALL DOOR JAMBS 4" FROM ADJACENT PERPENDICULAR WALL UNLESS NOTED OTHERWISE.
- STRUCTURAL CALCULATIONS FOR SHOP FABRICATED WOOD TRUSSES, WINDOW / DOOR / OVERHEAD DOOR HEADERS, AND FOUNDATION AND FOOTING DESIGN PROVIDED BY OTHERS.
- PLUMBING, MECHANICAL, AND ELECTRICAL DESIGN TO BE PROVIDED BY OTHERS.

ROOM SCHEDULE

Name	Area
OFFICE	92.10 SF
MASTER BEDROOM	200.86 SF
MASTER LAVATORY	78.59 SF
MASTER BATH	37.09 SF
MASTER CLOSET	54.70 SF
COAT CLOSET	7.88 SF
MUD ROOM	73.10 SF
BATHROOM	142.38 SF
BEDROOM 2	72.61 SF
BEDROOM 3	130.00 SF
KITCHEN	189.36 SF
DINING	316.98 SF
FAMILY ROOM	139.81 SF
LIVING	334.00 SF
TOILET	34.28 SF
PRIVATE HALL	149.43 SF
LINEN STORAGE	34.23 SF
CLOSET 3A	13.19 SF
CLOSET 4A	13.19 SF
CLOSET 4B	9.12 SF
CLOSET 3B	9.12 SF
SHOWER	33.71 SF
LAVATORY SUITE	72.24 SF
BEDROOM 3	242.60 SF
BEDROOM 4	242.98 SF
PANTRY	Not Placed
CLOSET 2	6.67 SF
MASTER TOILET	17.24 SF
OFFICE STORAGE	23.30 SF
ENTRY HALL	197.52 SF
LINEN	3.43 SF
TOTAL SQUARE FOOTAGE	2,971.20 SF

HOPE HOUSE

A PROJECT OF:
LIVING LIGHT CHRISTIAN
CHURCH AND
J. SNYDER DESIGN

PROJECT INFORMATION

3812 15TH STREET
KENOSHA, WI 53144


ISSUANCE AND REVISIONS

DATE	DESCRIPTION
------	-------------

SHEET INFORMATION



D6 PERSPECTIVE LOOKING SOUTHWEST

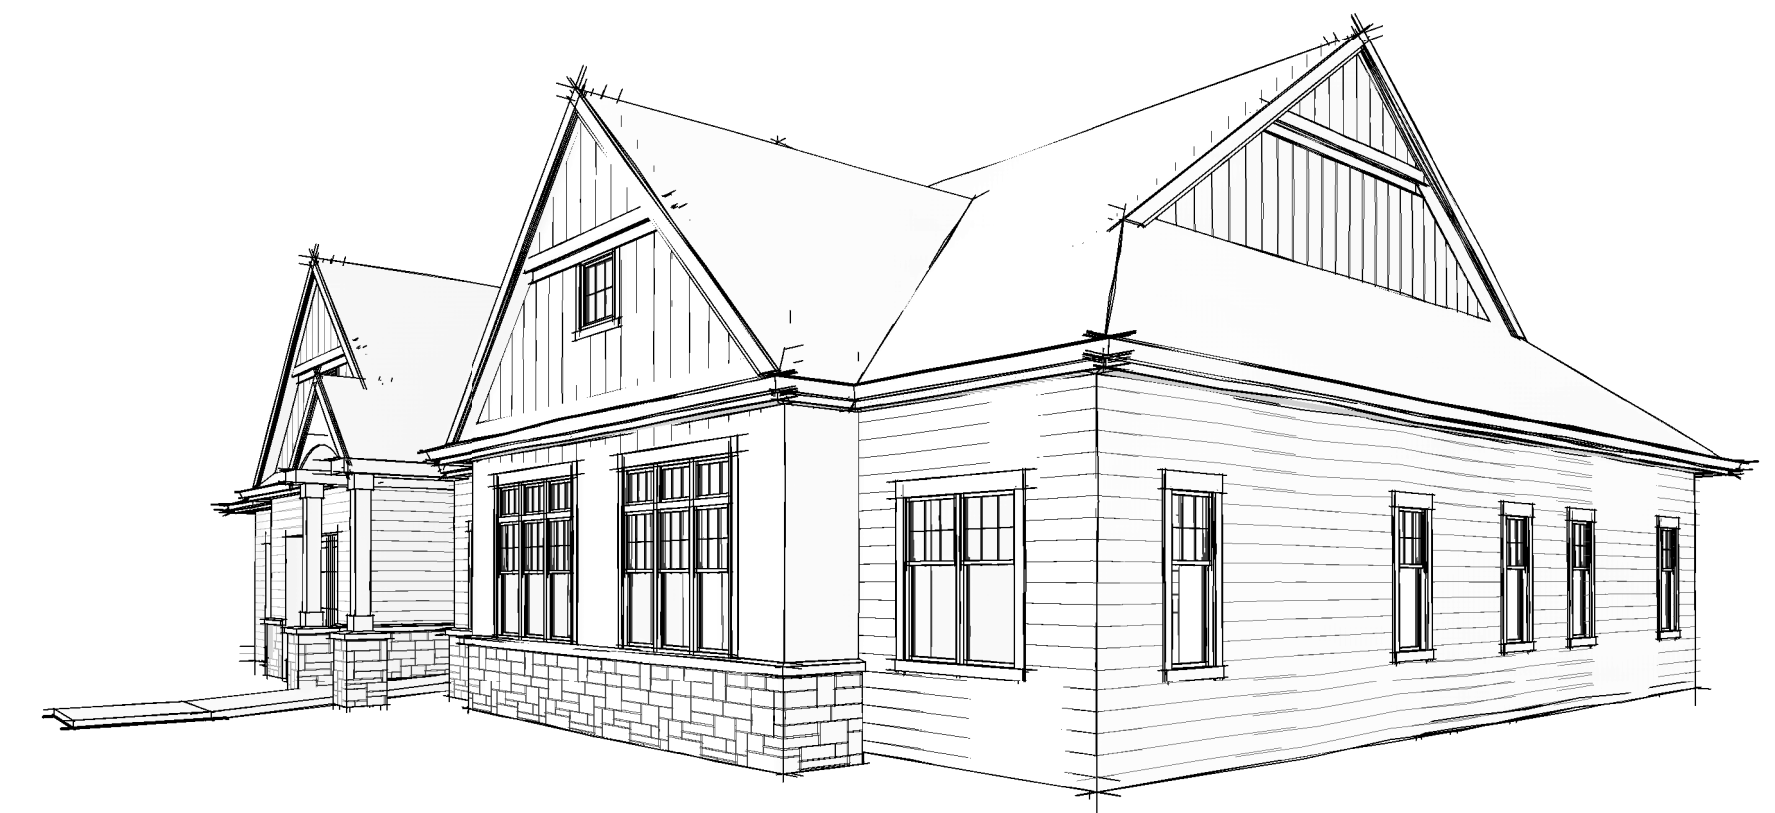

C6 PERSPECTIVE LOOKING NORTHWEST



B6 PERSPECTIVE LOOKING NORTH B



A6 PERSPECTIVE LOOKING NORTH A

A2 FIRST FLOOR

FIRST FLOOR PLAN

A101

HOPE HOUSE

A PROJECT OF:
LIVING LIGHT CHRISTIAN
CHURCH AND
J. SNYDER DESIGN

PROJECT INFORMATION

3812 15TH STREET
KENOSHA, WI 53144


ISSUANCE AND REVISIONS

DATE	DESCRIPTION
------	-------------


SHEET INFORMATION

ROOF PLAN

A102

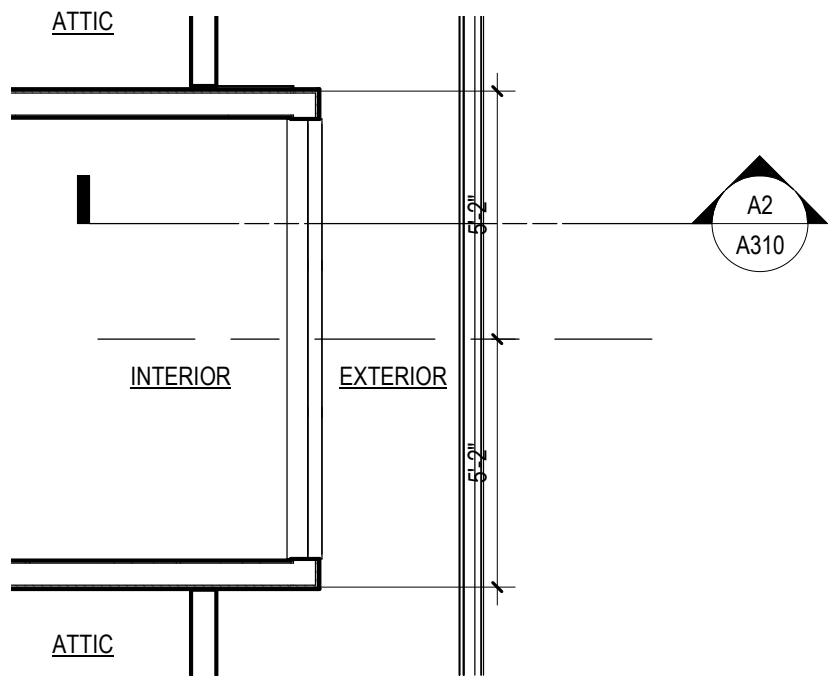


E7 LIVING ROOM DORMER PLAN
1/4" = 1'-0"

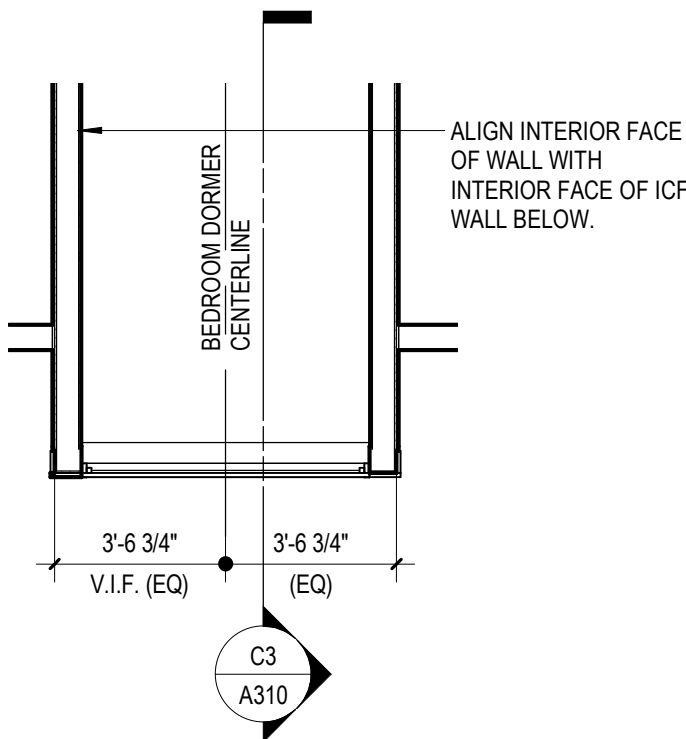


D7 BEDROOM DORMER PLAN
1/4" = 1'-0"

SHEET NOTES - FLOOR PLAN

- ALL EXTERIOR ICF WALLS ARE DIMENSIONED TO EXTERIOR FACE OF BOARD INSULATION UNLESS NOTED OTHERWISE.
- ALL INTERIOR WOOD STUD WALLS ARE DIMENSIONED TO FACE OF STUD. ALL EXTERIOR WOOD WALLS AND RAFTER FRAMED WALLS ARE DIMENSIONED TO OUTSIDE FACE OF SHEATHING, WHICH IS FIGURED TO BE 1/2" SHEATHING (STRUCTURAL ENGINEERING BY OTHERS).
- PROVIDE BLOCKING WITHIN INTERIOR WALLS TO SUPPORT WALL MOUNTED ACCESSORIES INCLUDING BUT NOT LIMITED TO CASEWORK, COUNTERTOPS, TOWEL BARS, TOILET PAPER DISPENSERS, CLOSET SHELVING, AND WINDOW SEAT CASEWORK.
- ALL DOORS ARE 3'-0" UNLESS NOTED OTHERWISE.
- PROVIDE MOISTURE RESISTANT AND MILDEW RESISTANT TYPE GYPSUM BOARD AT PLUMBING FIXTURE WALLS.
- PROVIDE REQUIRED UTILITY SERVICES TO EQUIPMENT, FURNISHINGS AND APPLIANCES.
- PROVIDE MOISTURE RESISTANT AND MOLD RESISTANT GYPSUM BOARD AT PLUMBING FIXTURE WALLS.
- LOCATE ALL DOOR JAMBS 4" FROM ADJACENT PERPENDICULAR WALL UNLESS NOTED OTHERWISE.
- STRUCTURAL CALCULATIONS FOR SHOP FABRICATED WOOD TRUSSES, WINDOW / DOOR / OVERHEAD DOOR HEADERS, AND FOUNDATION AND FOOTING DESIGN PROVIDED BY OTHERS.
- PLUMBING, MECHANICAL, AND ELECTRICAL DESIGN TO BE PROVIDED BY OTHERS.

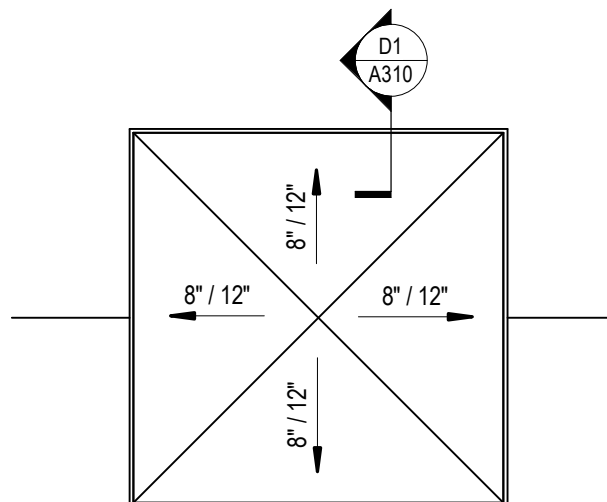

A7 CUPOLA ROOF PLAN
1/4" = 1'-0"

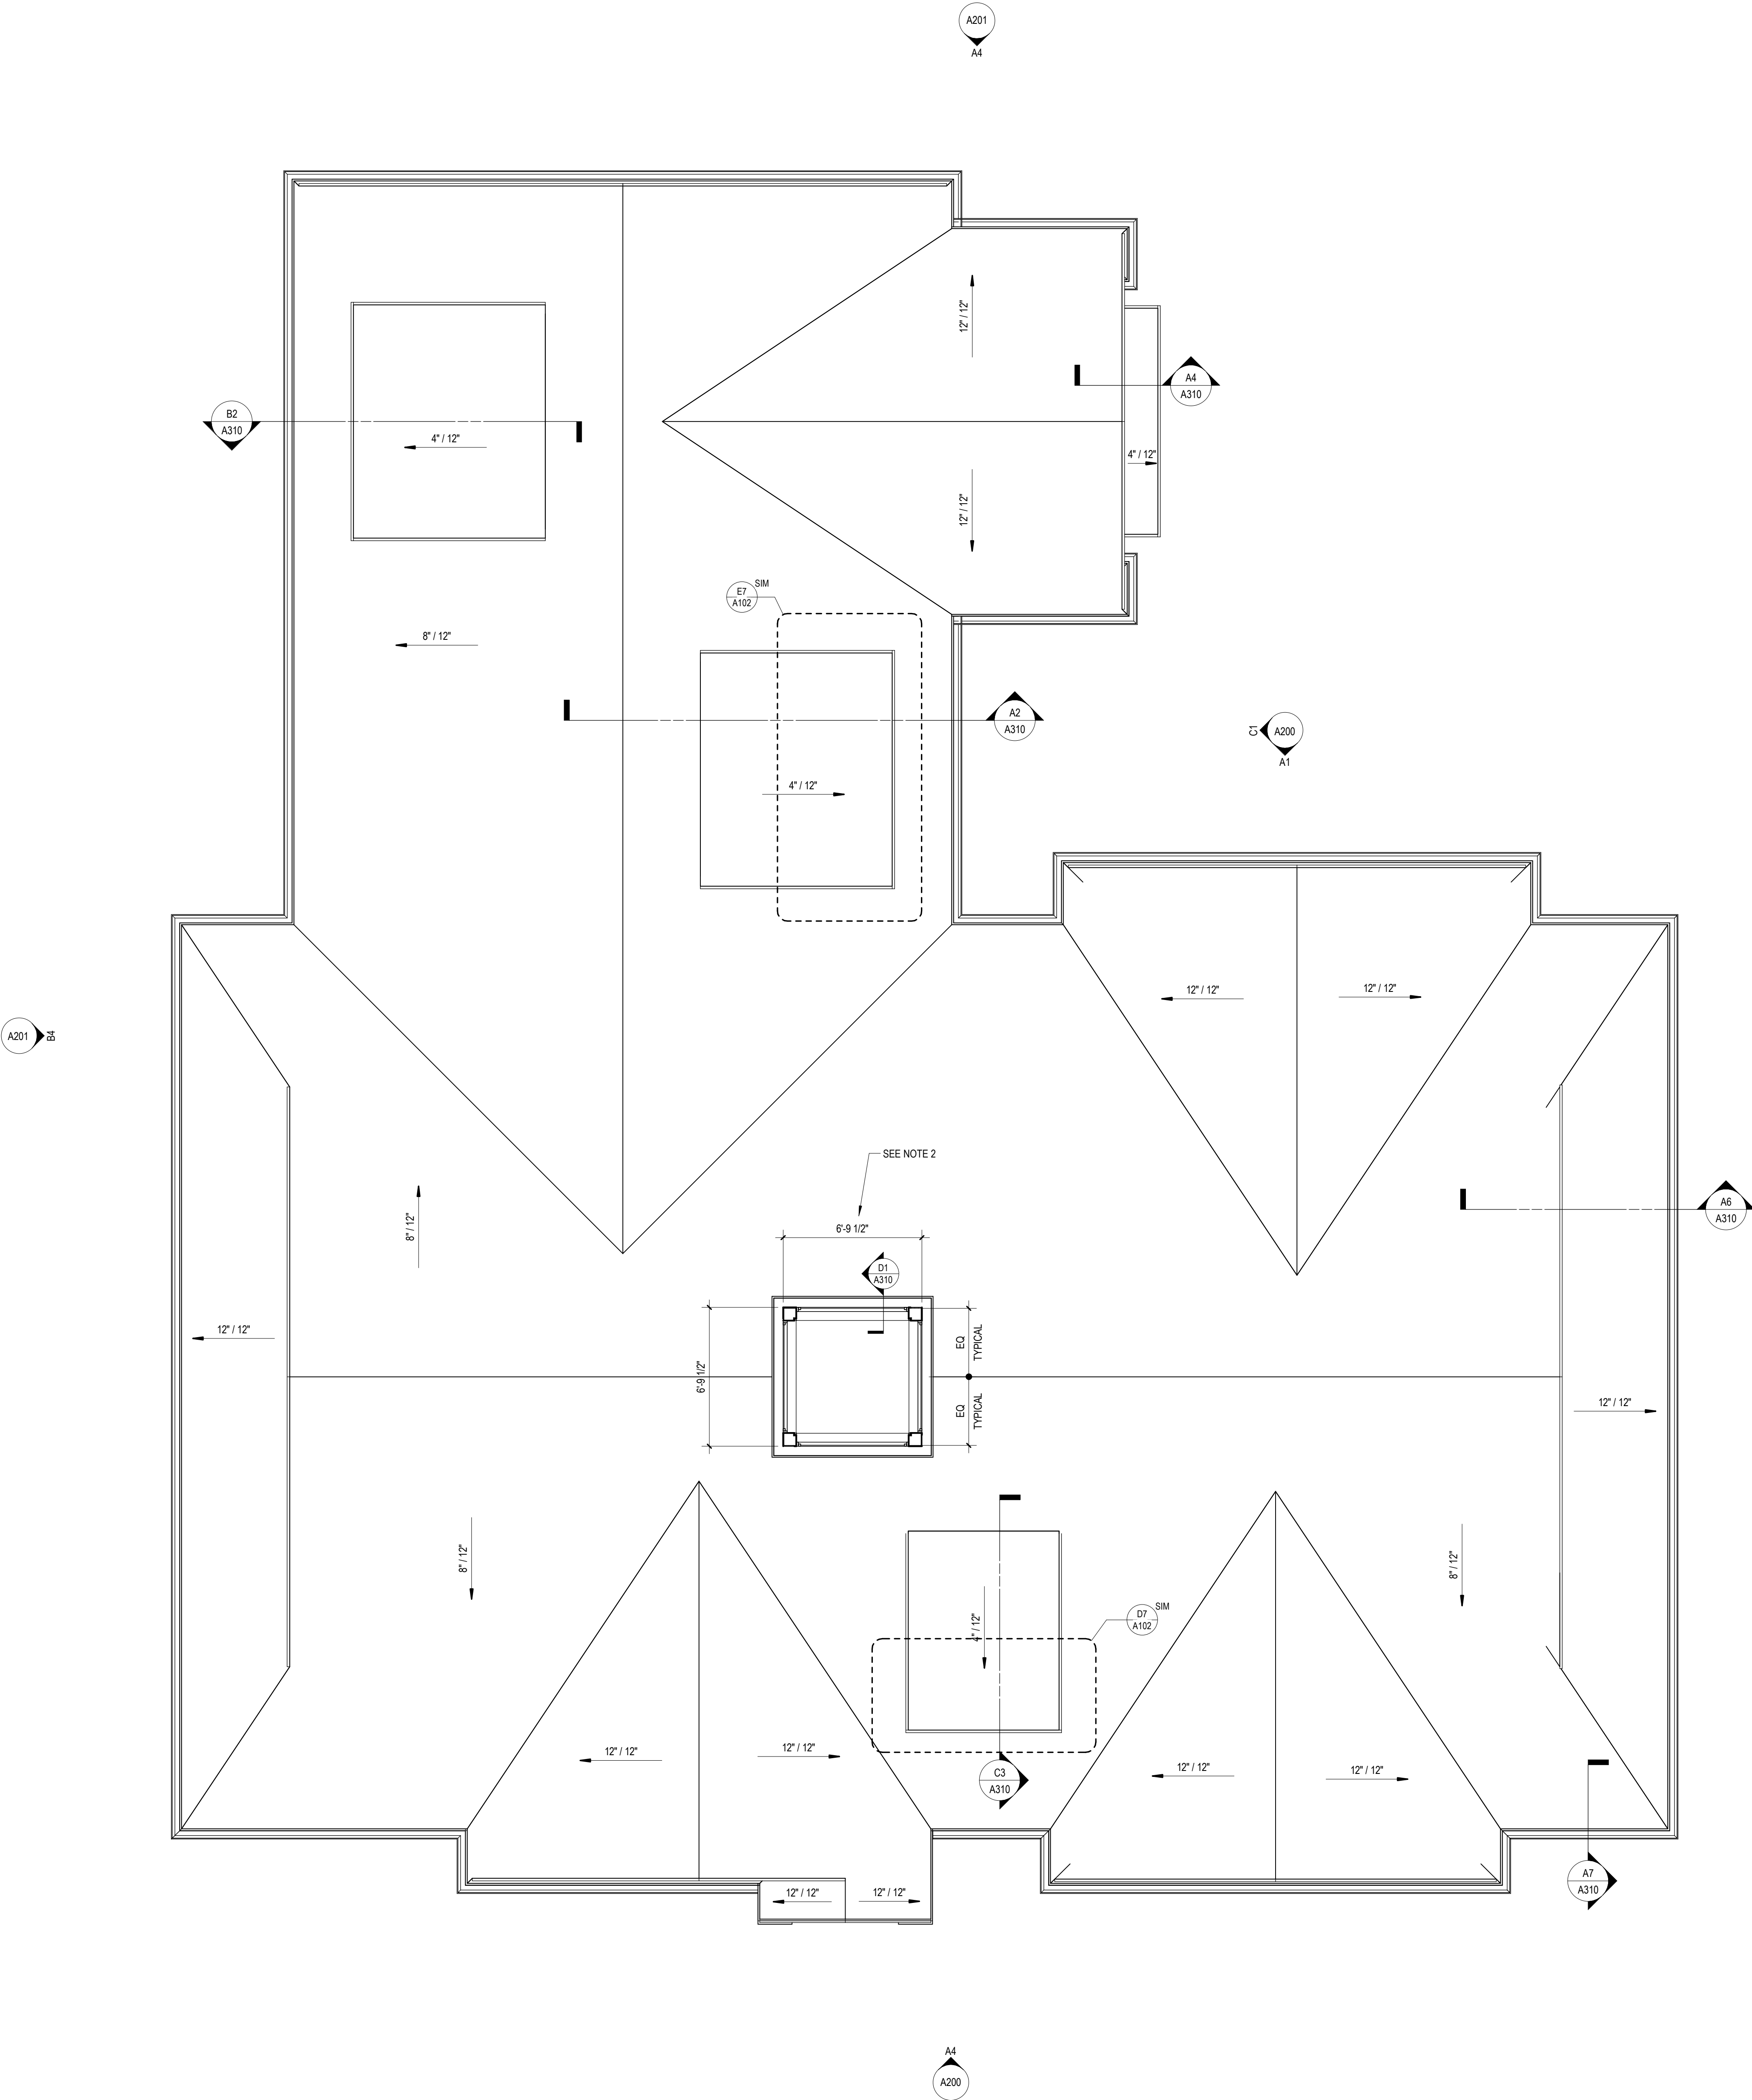

A3 ROOF PLAN
1/4" = 1'-0"

HOPE HOUSE

A PROJECT OF:
LIVING LIGHT CHRISTIAN
CHURCH AND
J. SNYDER DESIGN

PROJECT INFORMATION

3812 15TH STREET
KENOSHA, WI 53144


ISSUANCE AND REVISIONS

DATE	DESCRIPTION
------	-------------

SHEET INFORMATION

REFLECTED
CEILING PLAN

A110

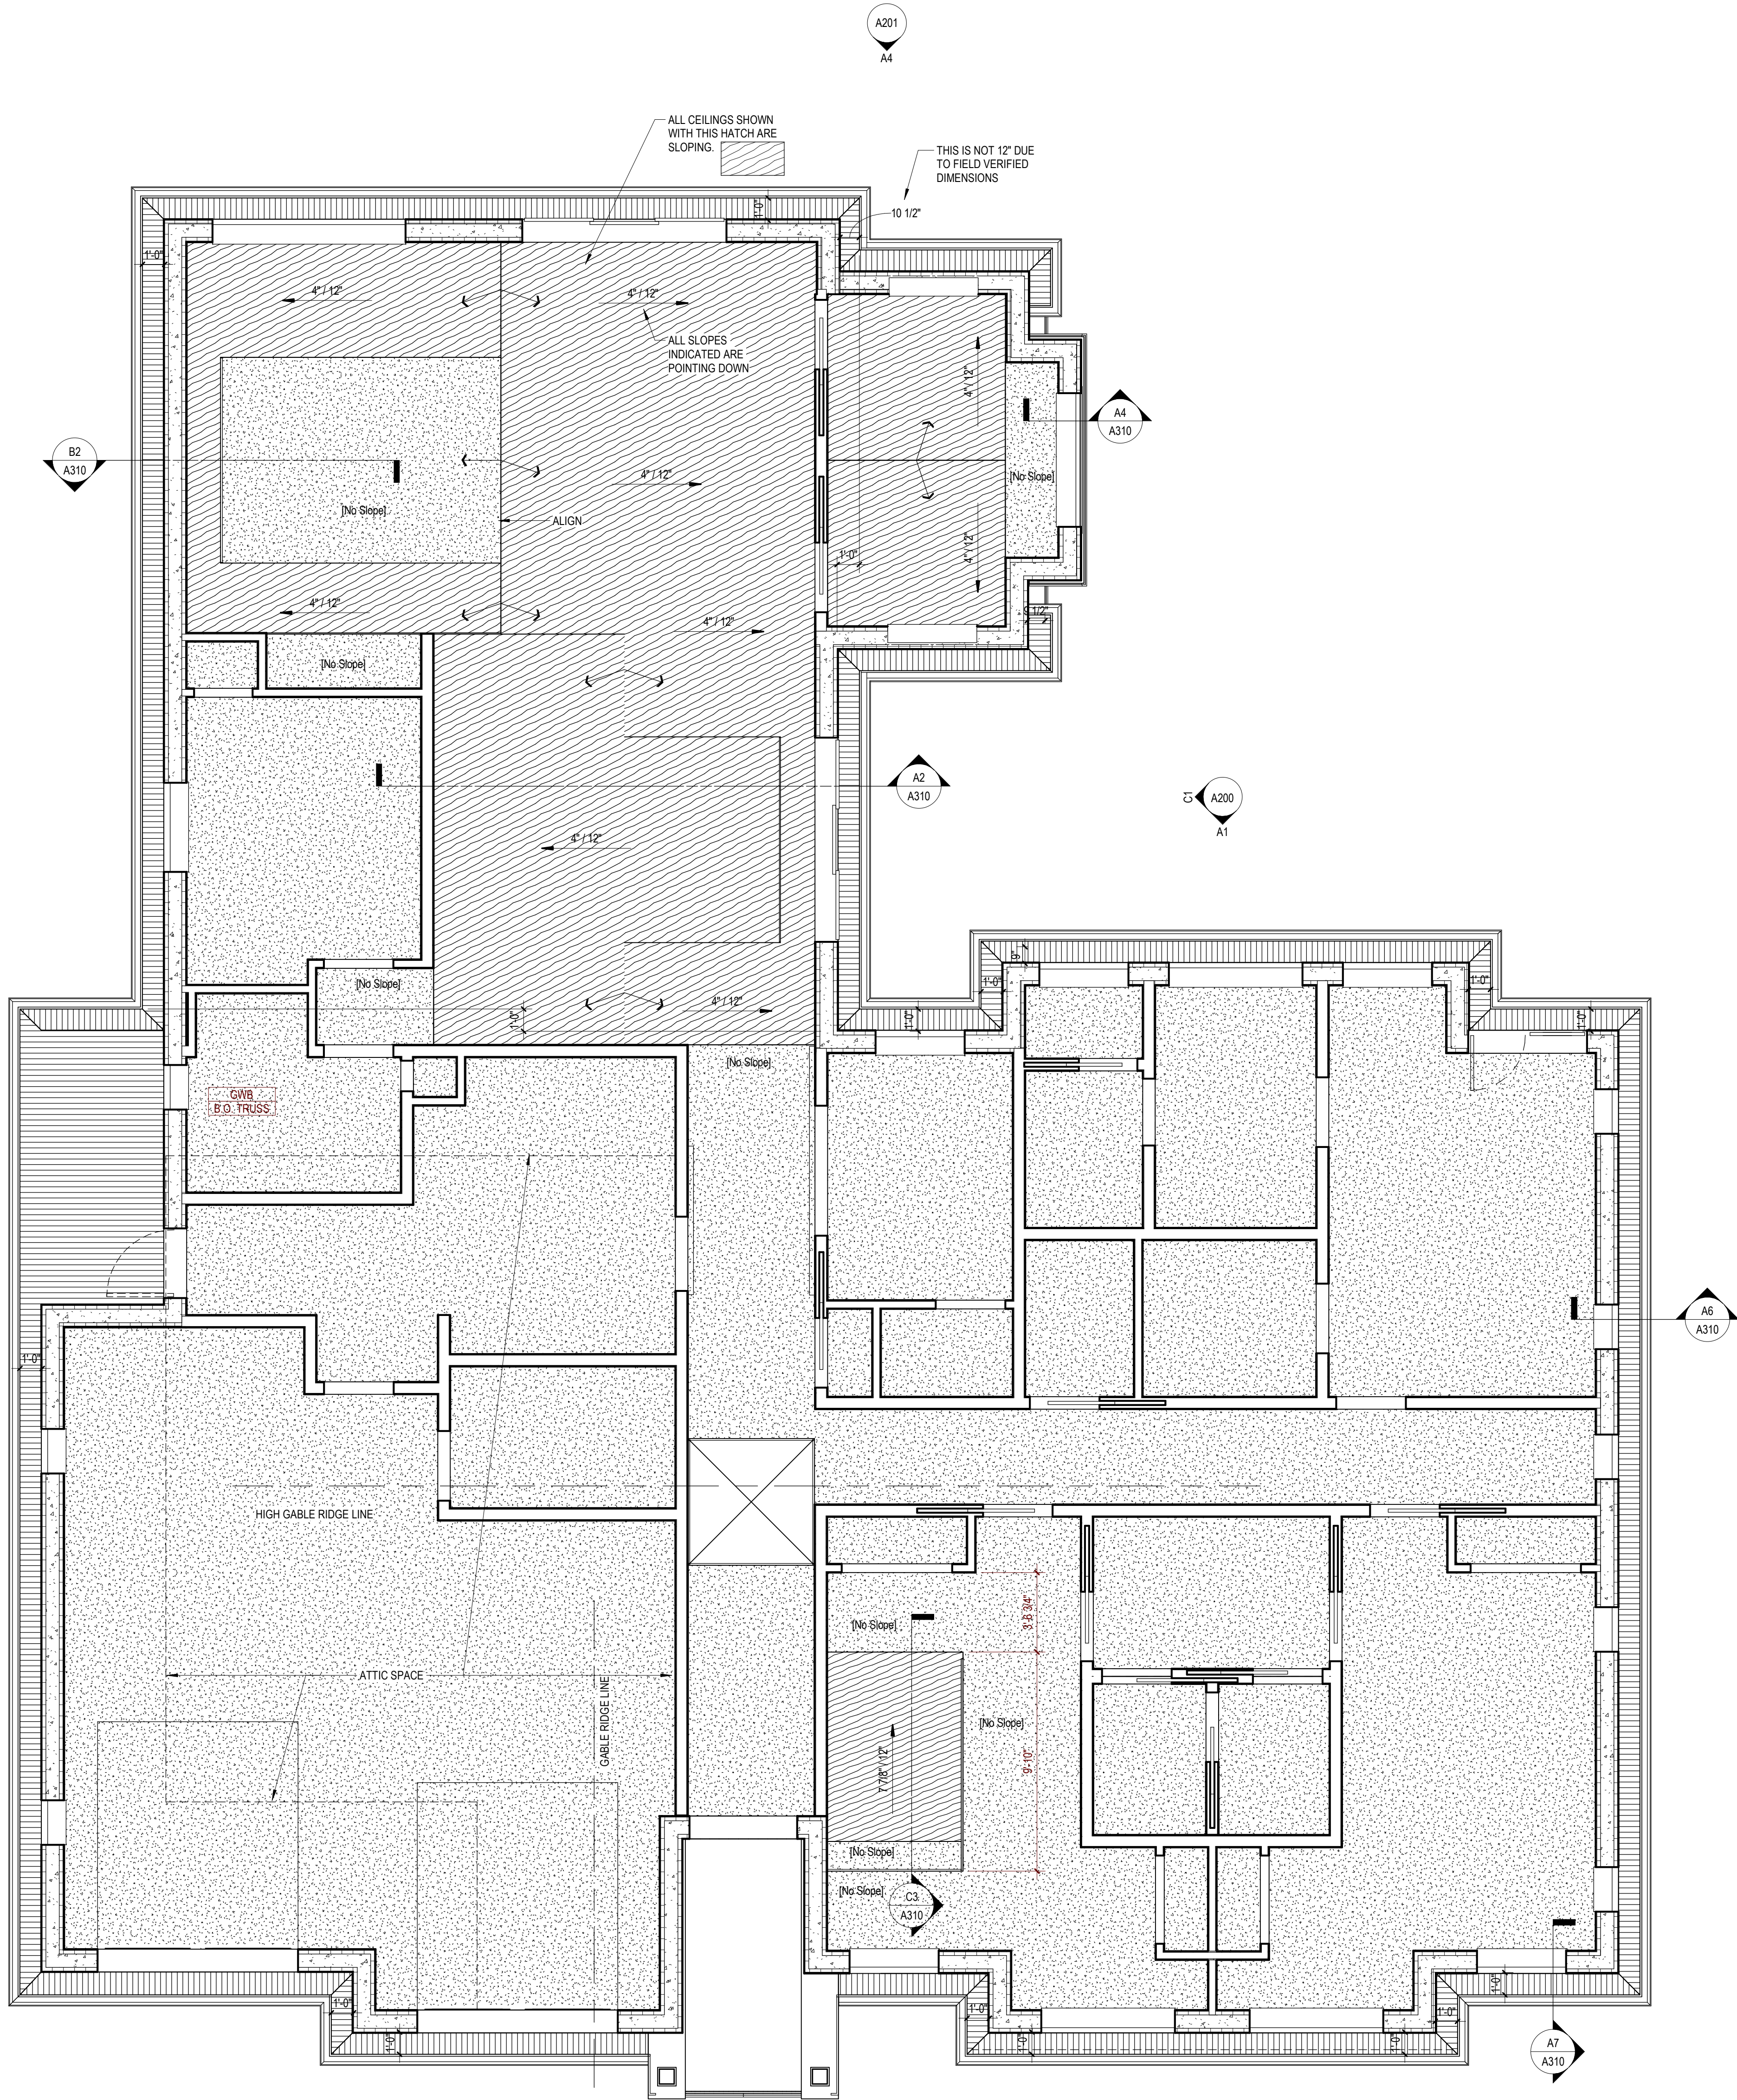

A3 FIRST FLOOR REFLECTED CEILING PLAN
1/4" = 1'-0"

1

2

3

4

5

6

7

KEYNOTES PER SHEET

HOPE
HOUSEA PROJECT OF:
LIVING LIGHT CHRISTIAN
CHURCH AND
J. SNYDER DESIGN

PROJECT INFORMATION

3812 15TH STREET
KENOSHA, WI 53144



ISSUANCE AND REVISIONS

DATE DESCRIPTION

SHEET INFORMATION

EXTERIOR
ELEVATIONS

A200

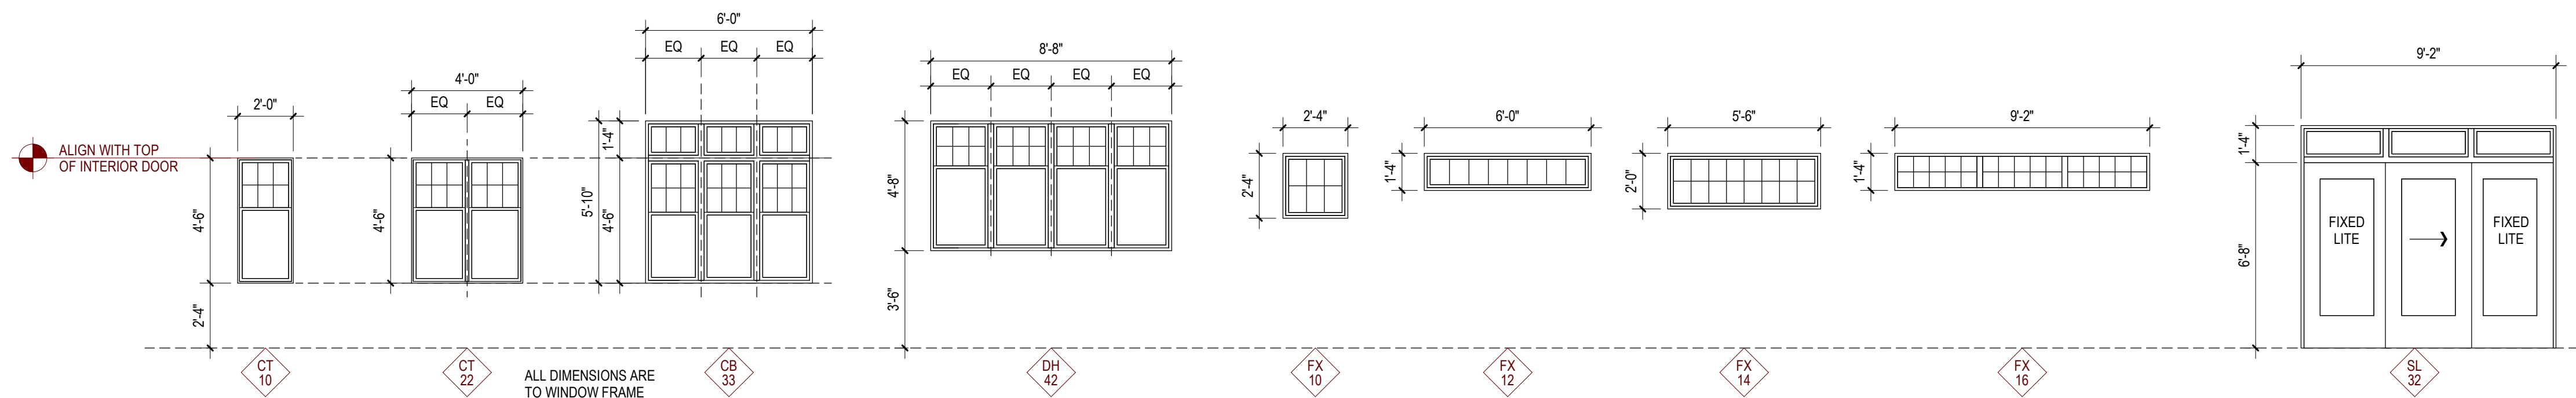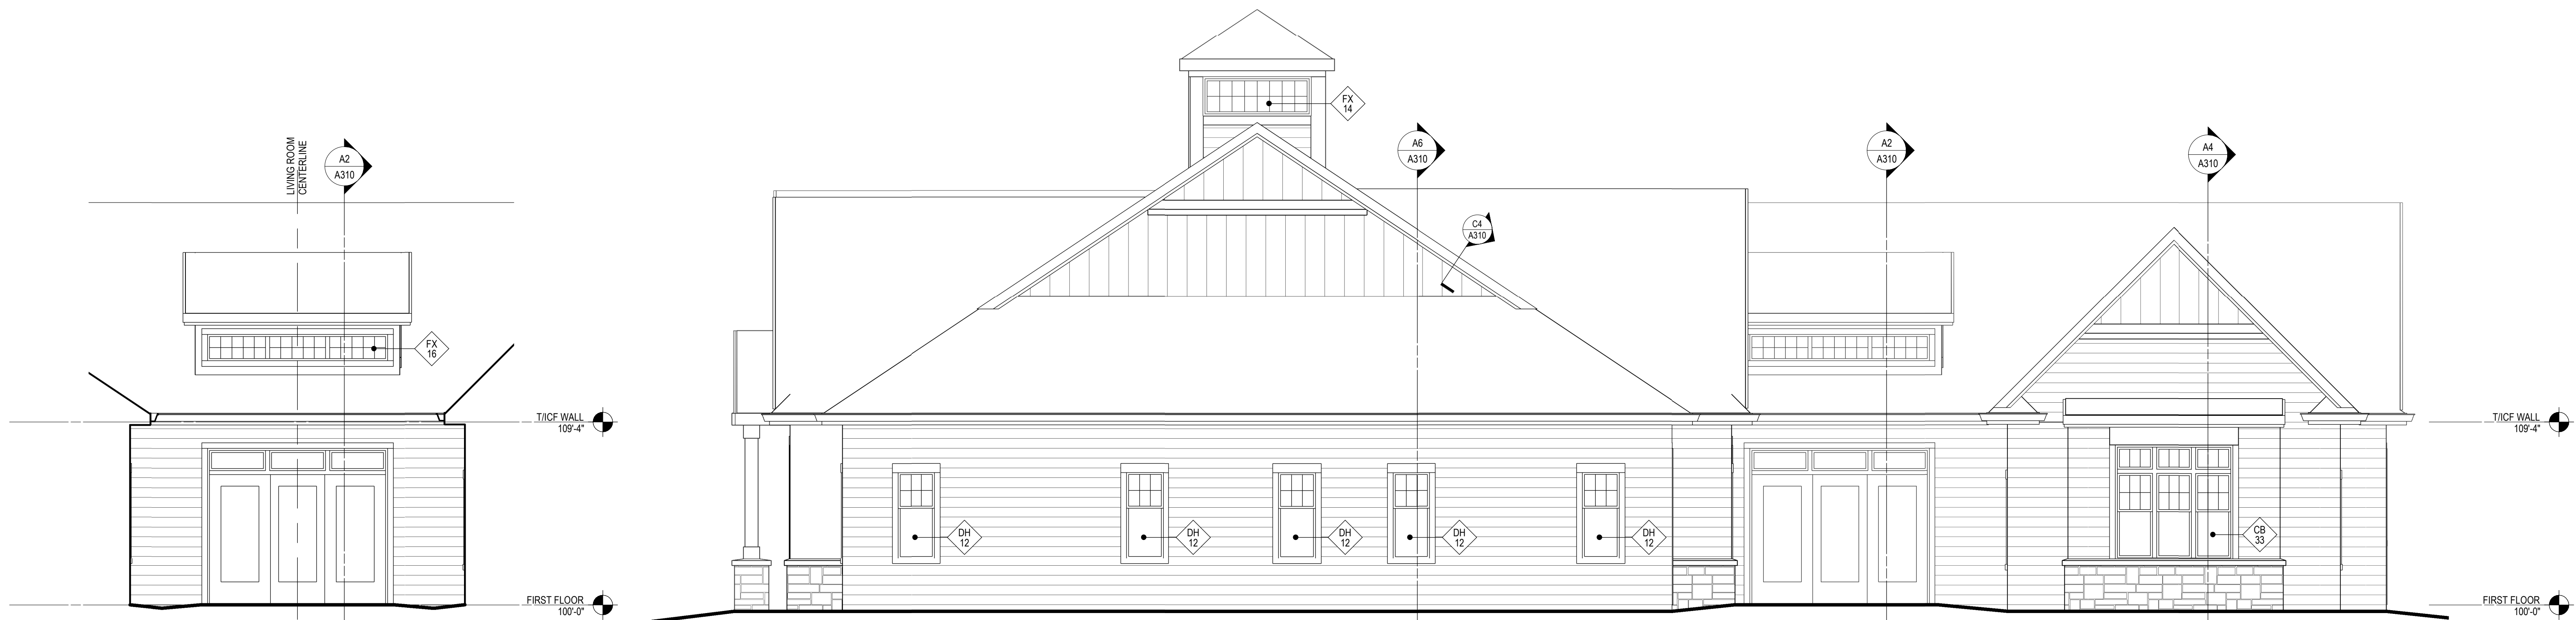FRAME TYPES
1/4" = 1'-0"C1 EAST ELEVATION AT LIVING ROOM
1/4" = 1'-0"B3 EAST ELEVATION
1/4" = 1'-0"A1 MASTER BATH ELEVATION
1/4" = 1'-0"A4 SOUTH ELEVATION
1/4" = 1'-0"

HOPE
HOUSE

A PROJECT OF:
LIVING LIGHT CHRISTIAN
CHURCH AND
J. SNYDER DESIGN

PROJECT INFORMATION

3812 15TH STREET
KENOSHA, WI 53144


ISSUANCE AND REVISIONS

DATE	DESCRIPTION
------	-------------


SHEET INFORMATION

EXTERIOR
ELEVATIONS

A201

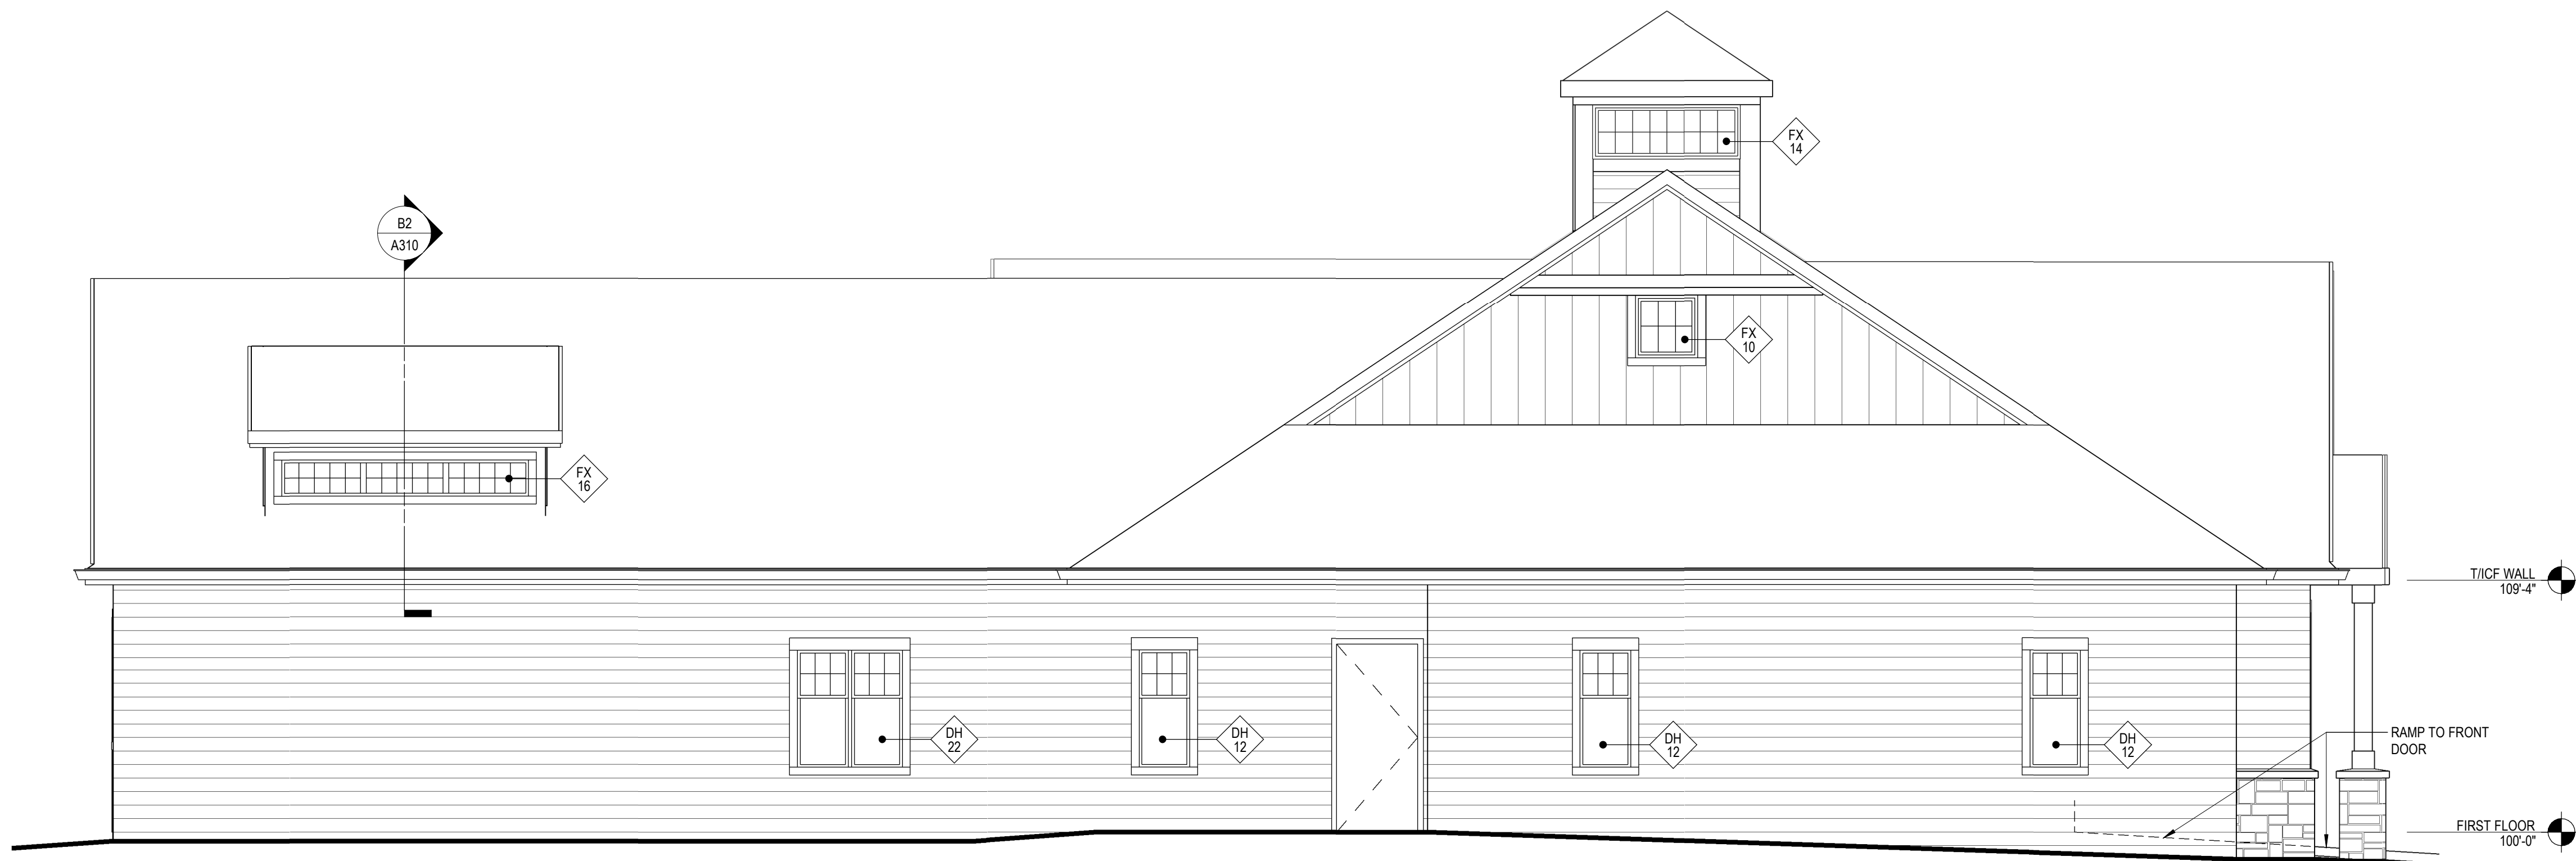

B4 WEST ELEVATION
1/4" = 1'-0"

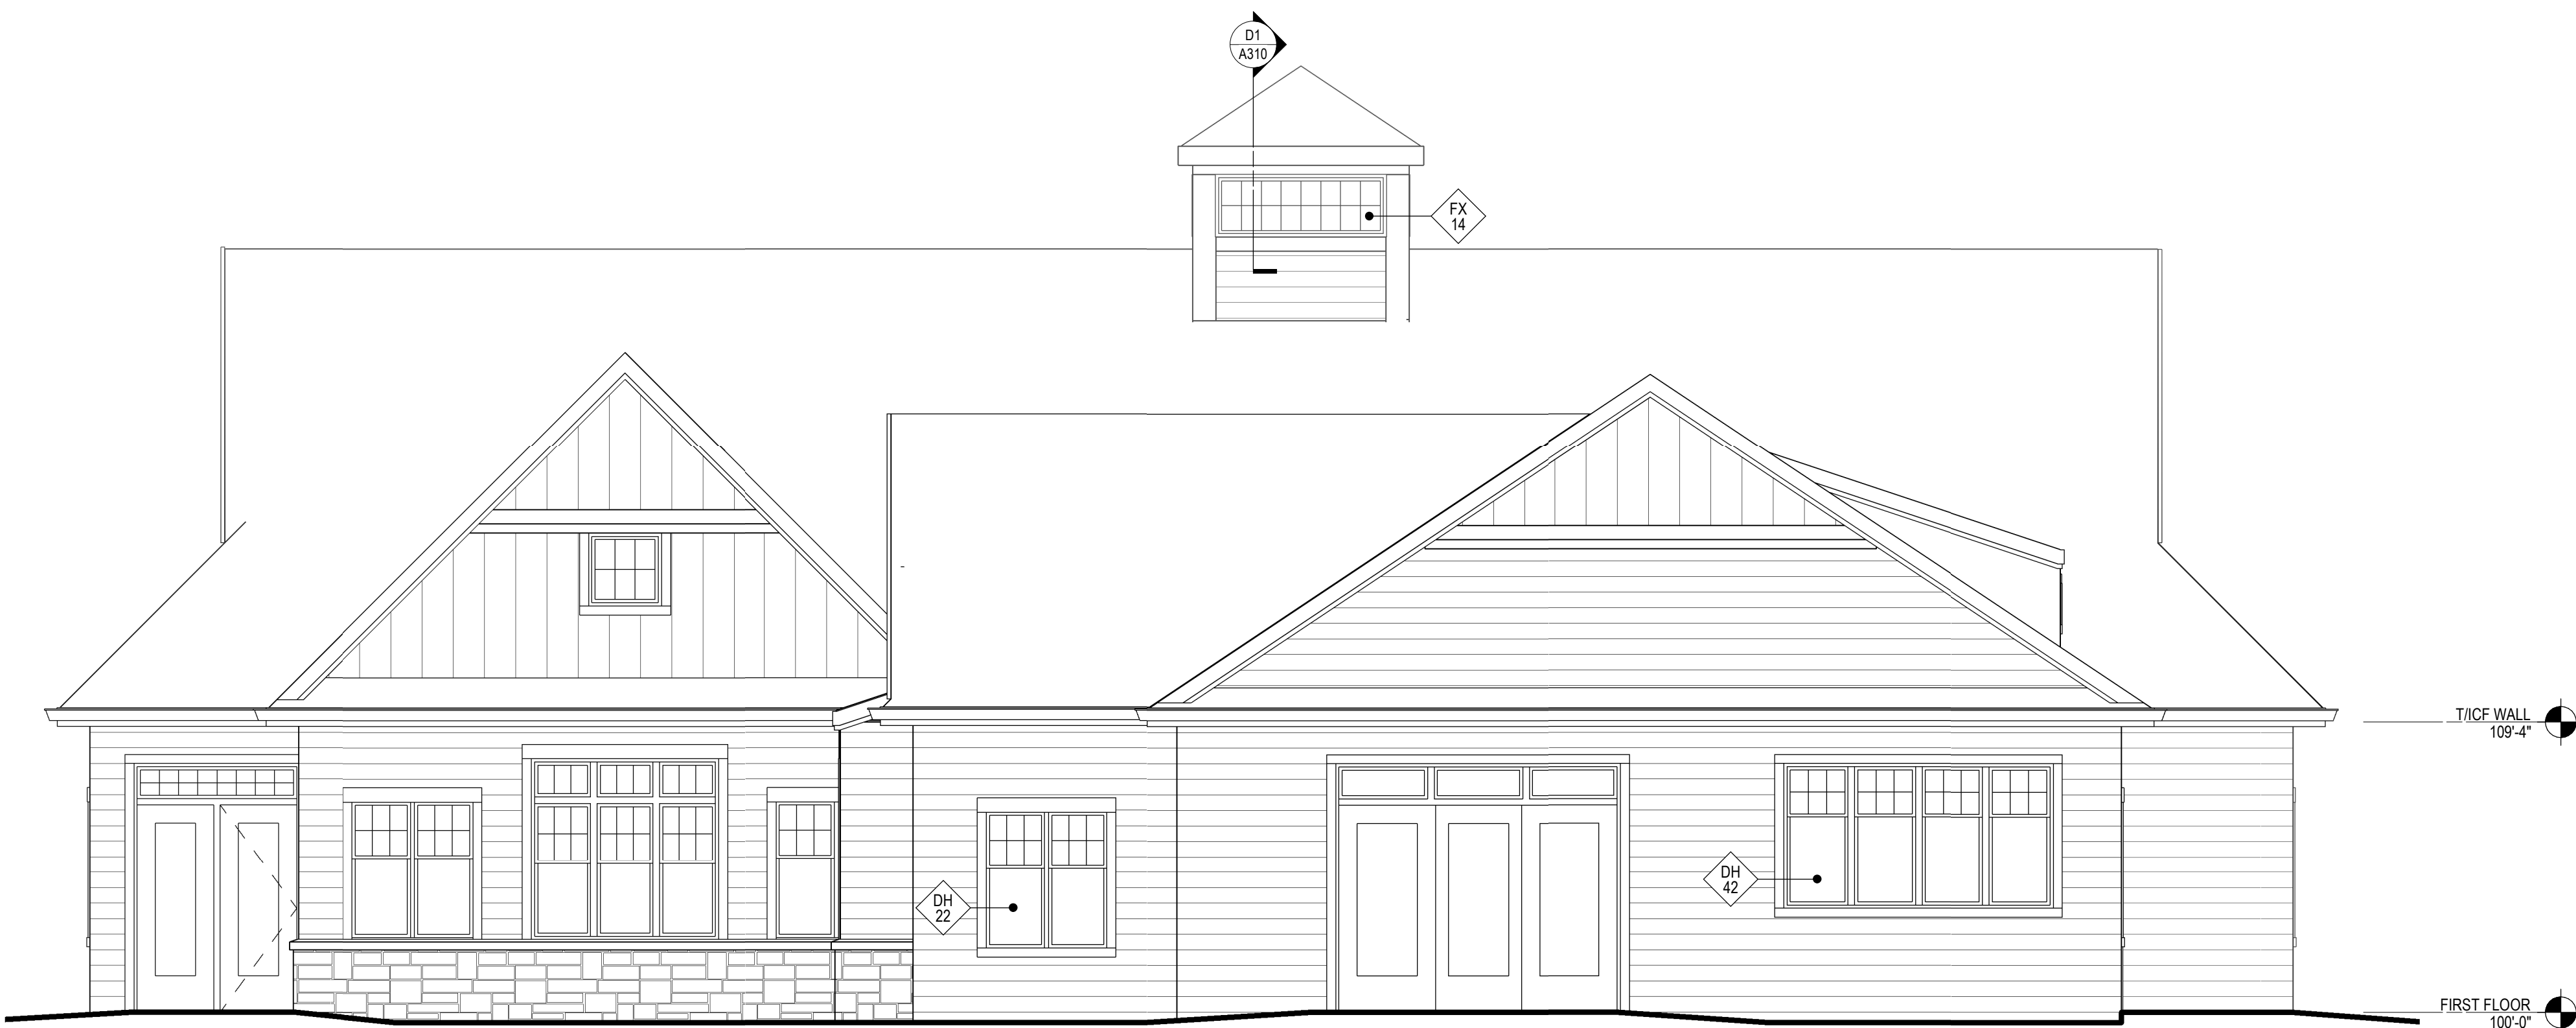

A4 NORTH ELEVATION
1/4" = 1'-0"

HOPE HOUSE

A PROJECT OF:
LIVING LIGHT CHRISTIAN
CHURCH AND
J. SNYDER DESIGN

PROJECT INFORMATION

3812 15TH STREET
KENOSHA, WI 53144

ISSUANCE AND REVISIONS

DATE	DESCRIPTION
------	-------------

SHEET INFORMATION

WALL SECTIONS

A310

E

D

C

B

A


E

D


C

B


A

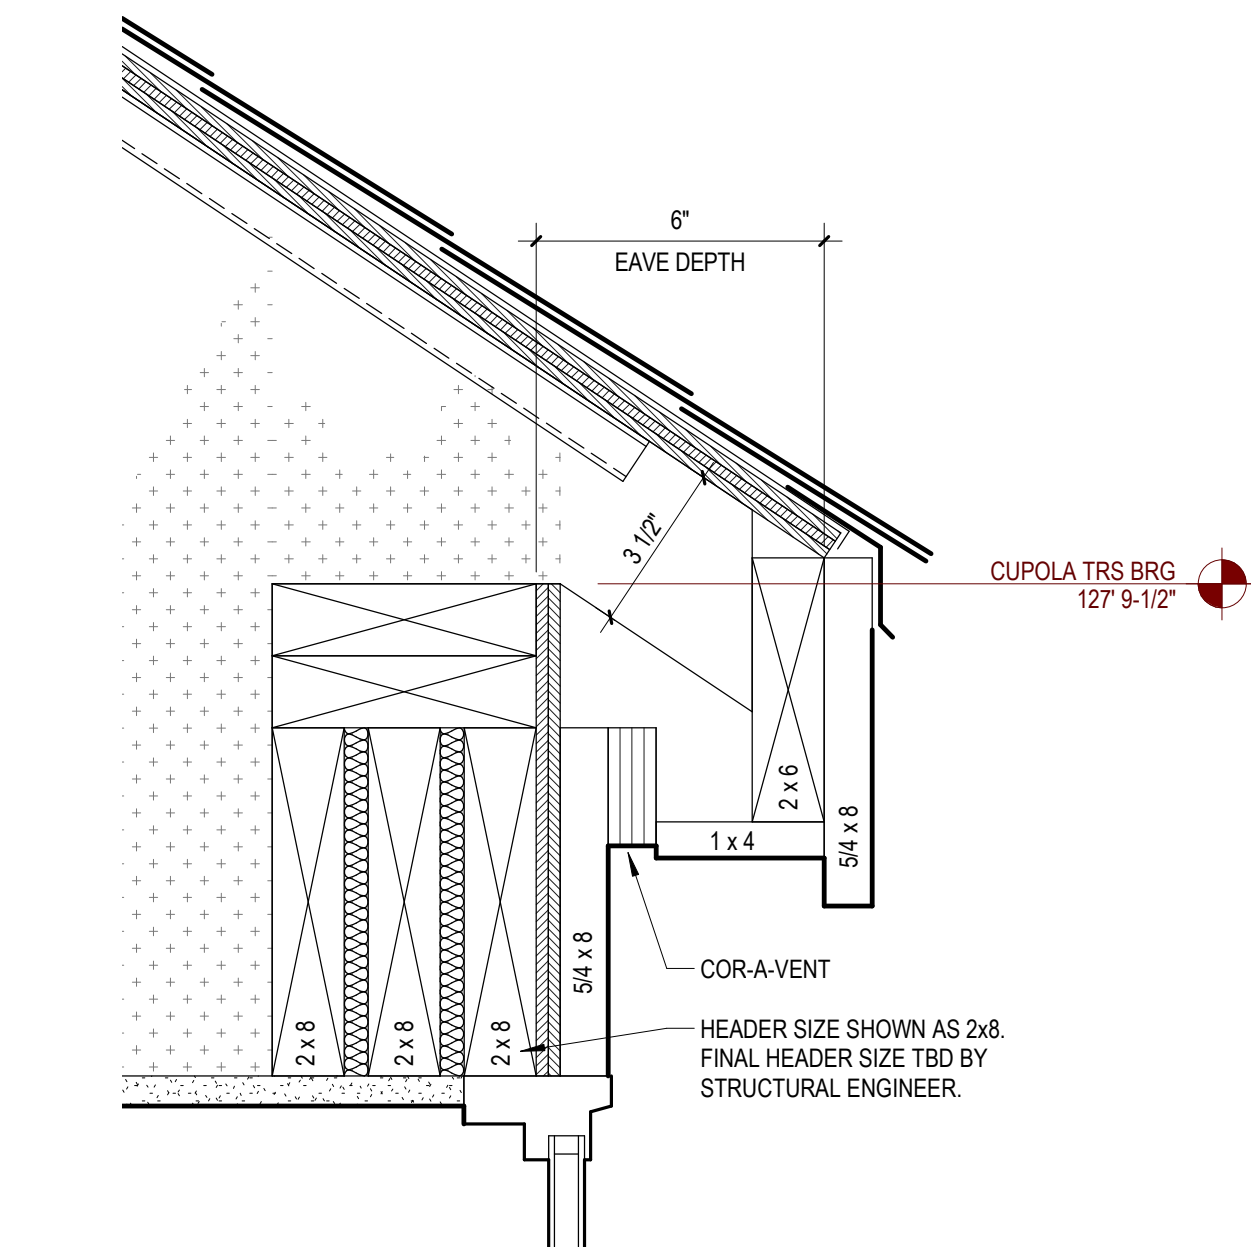


D1 CUPOLA SECTION DETAIL
3" = 1'-0"

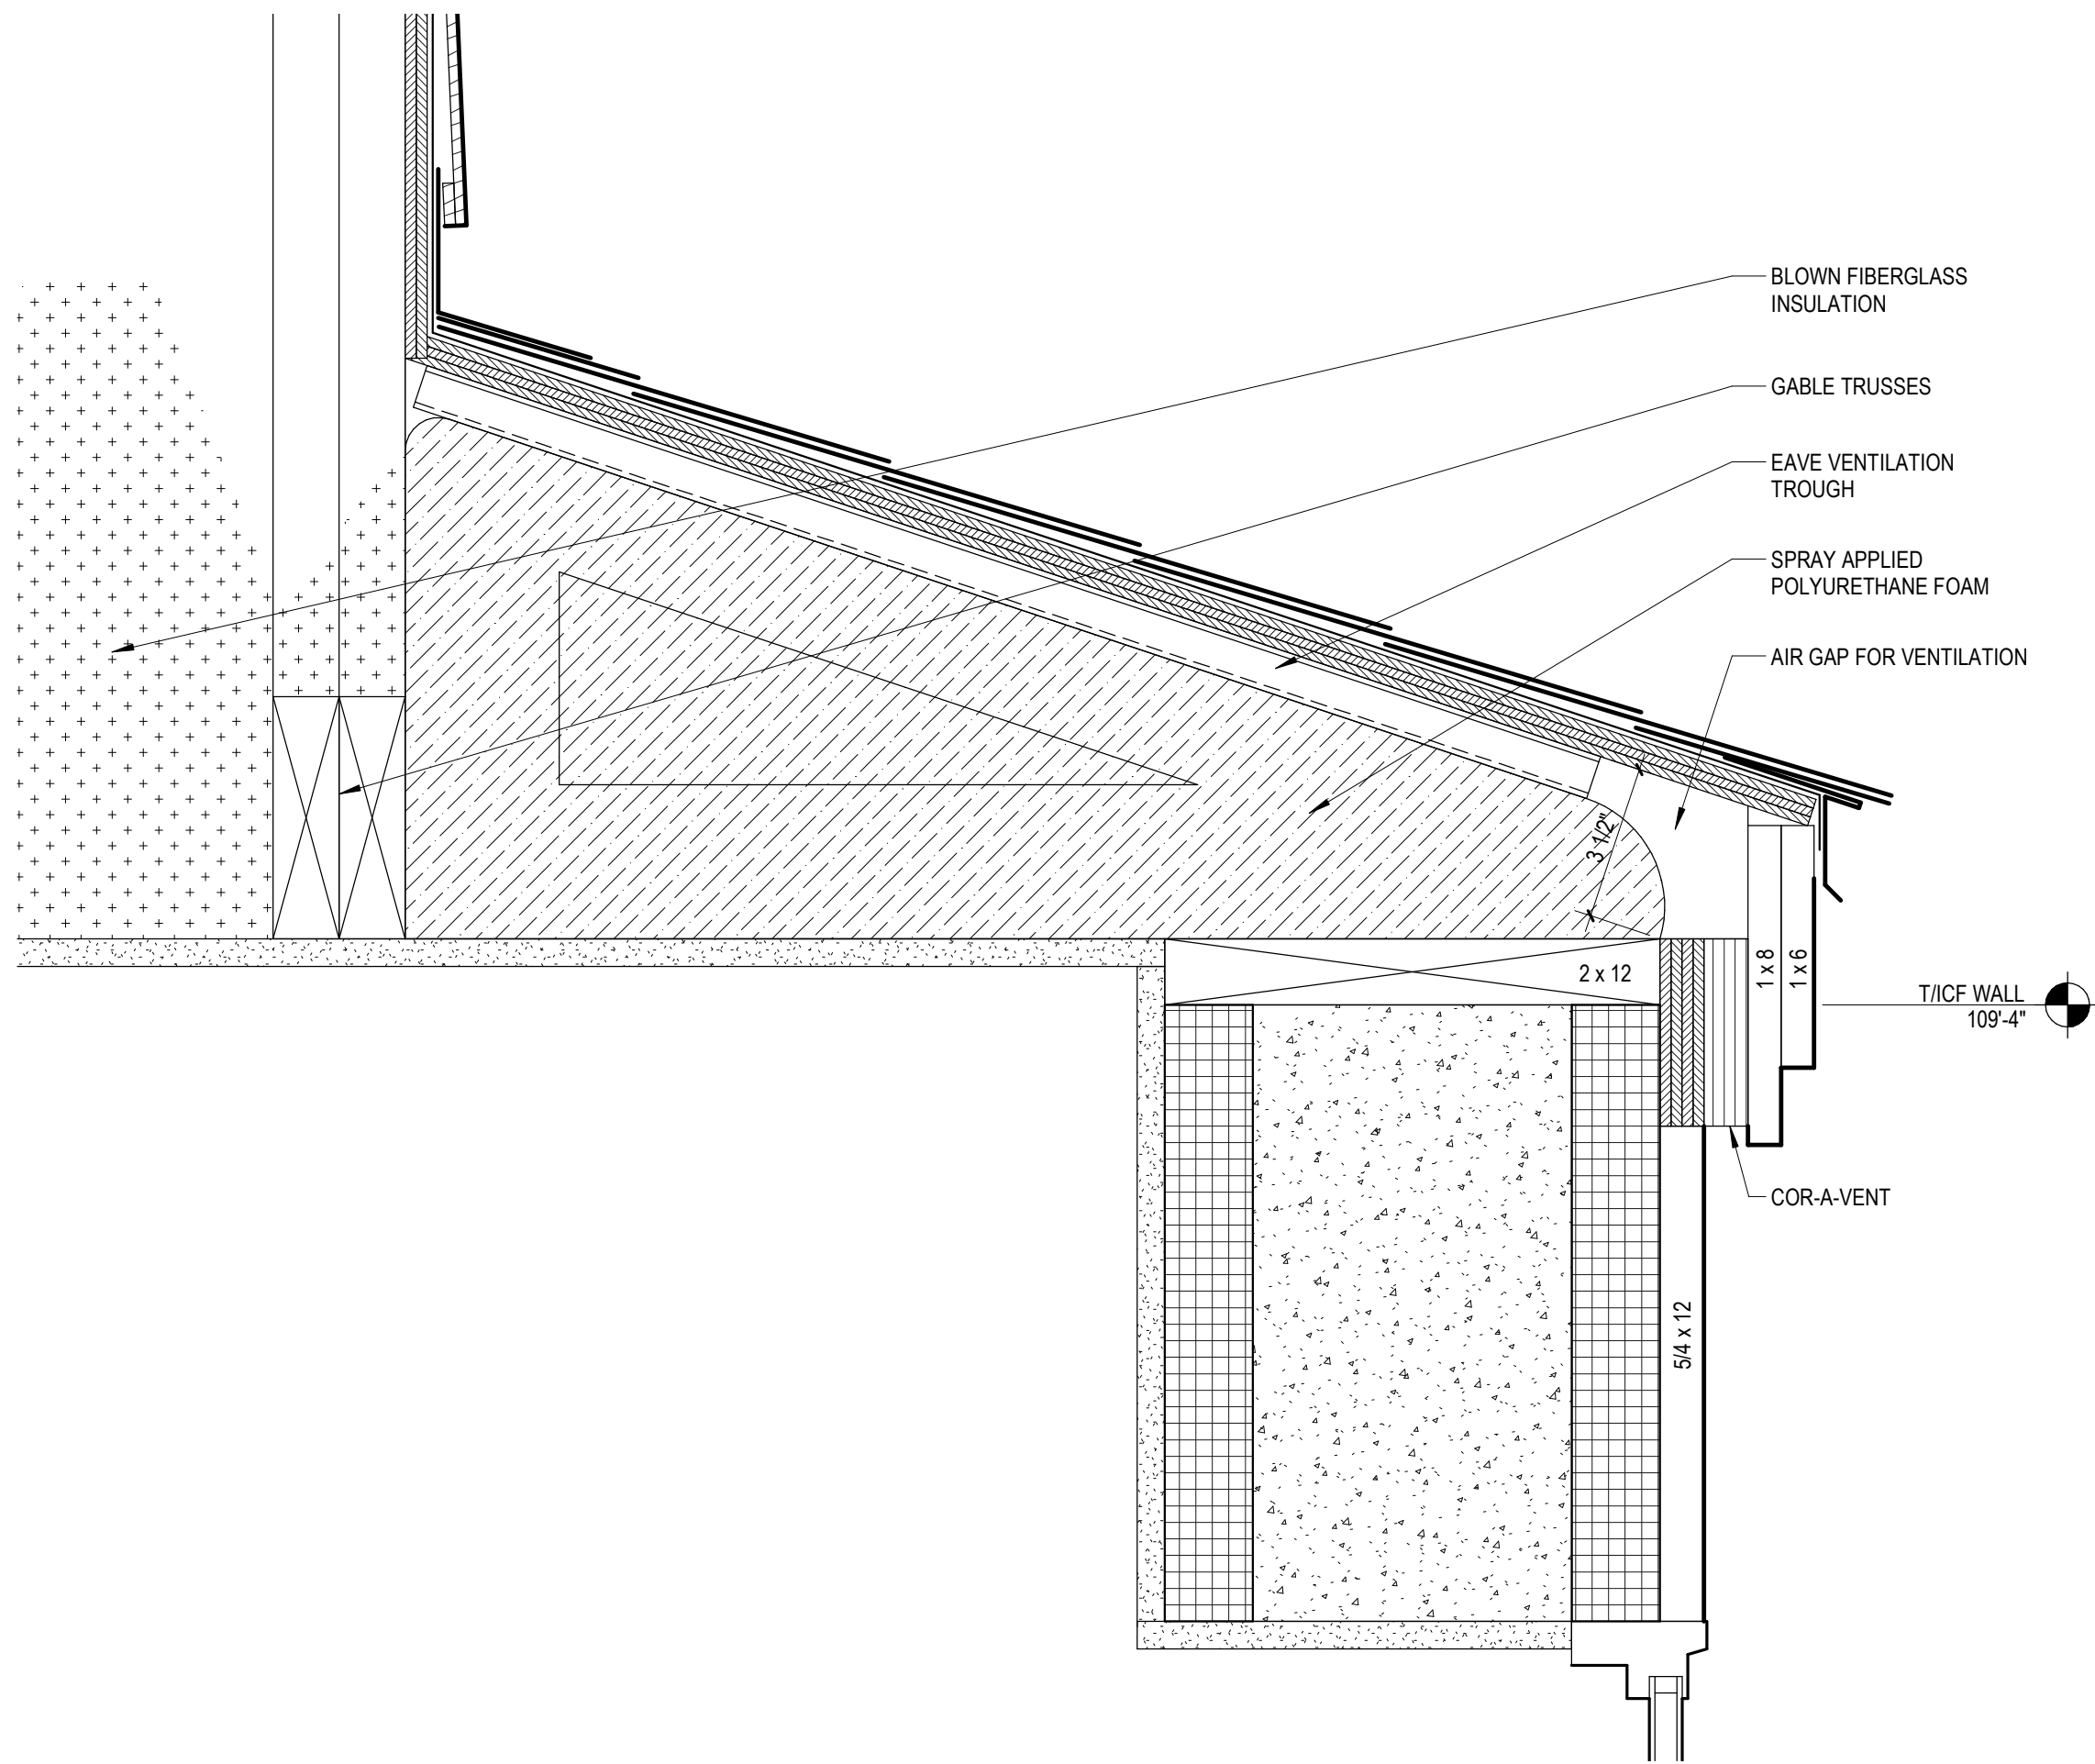


D3 WINDOW BAY EAVE DETAIL
3" = 1'-0"

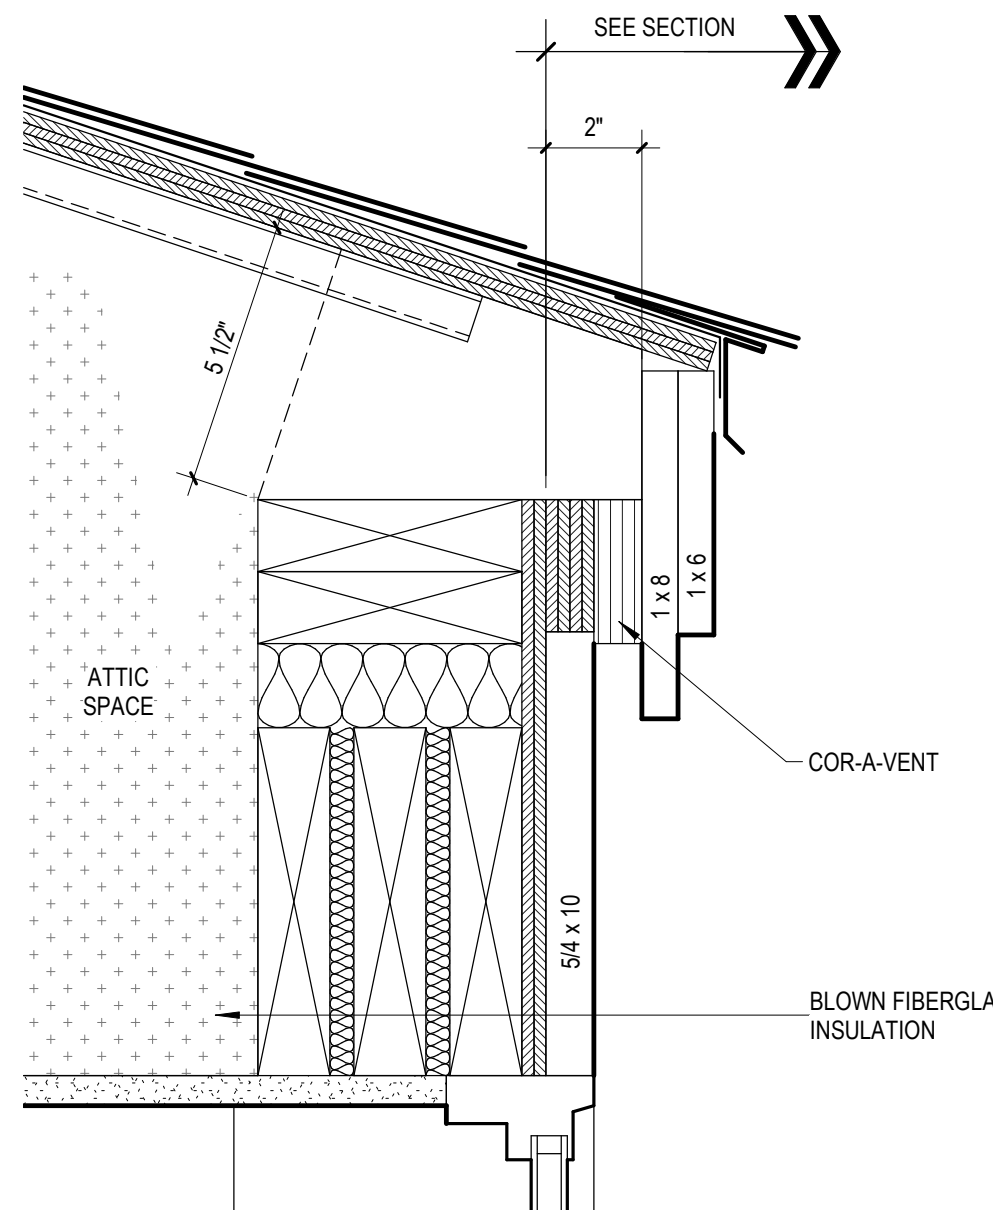


D4 DORMER DETAIL
3" = 1'-0"

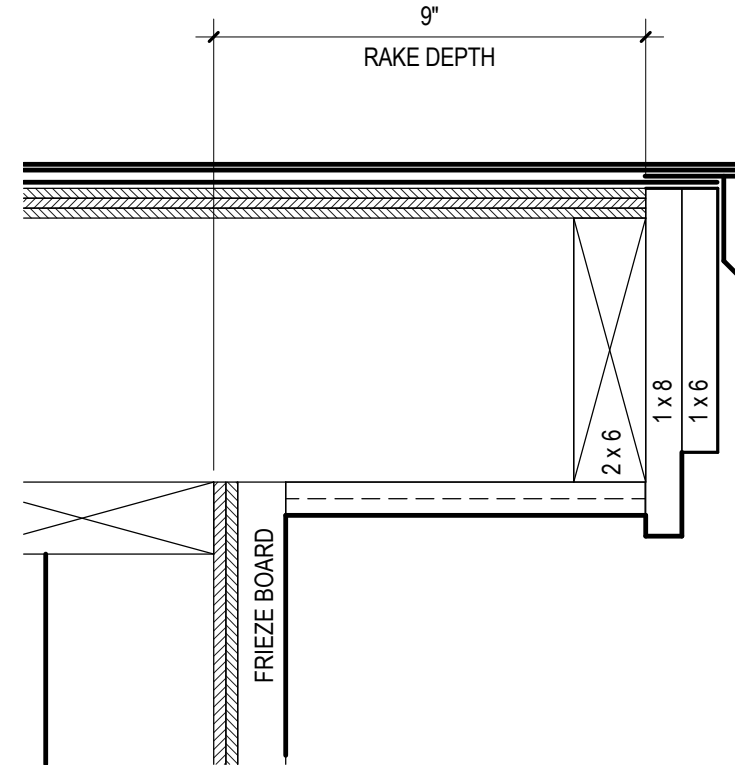


C4 RAKE DETAIL
3" = 1'-0"

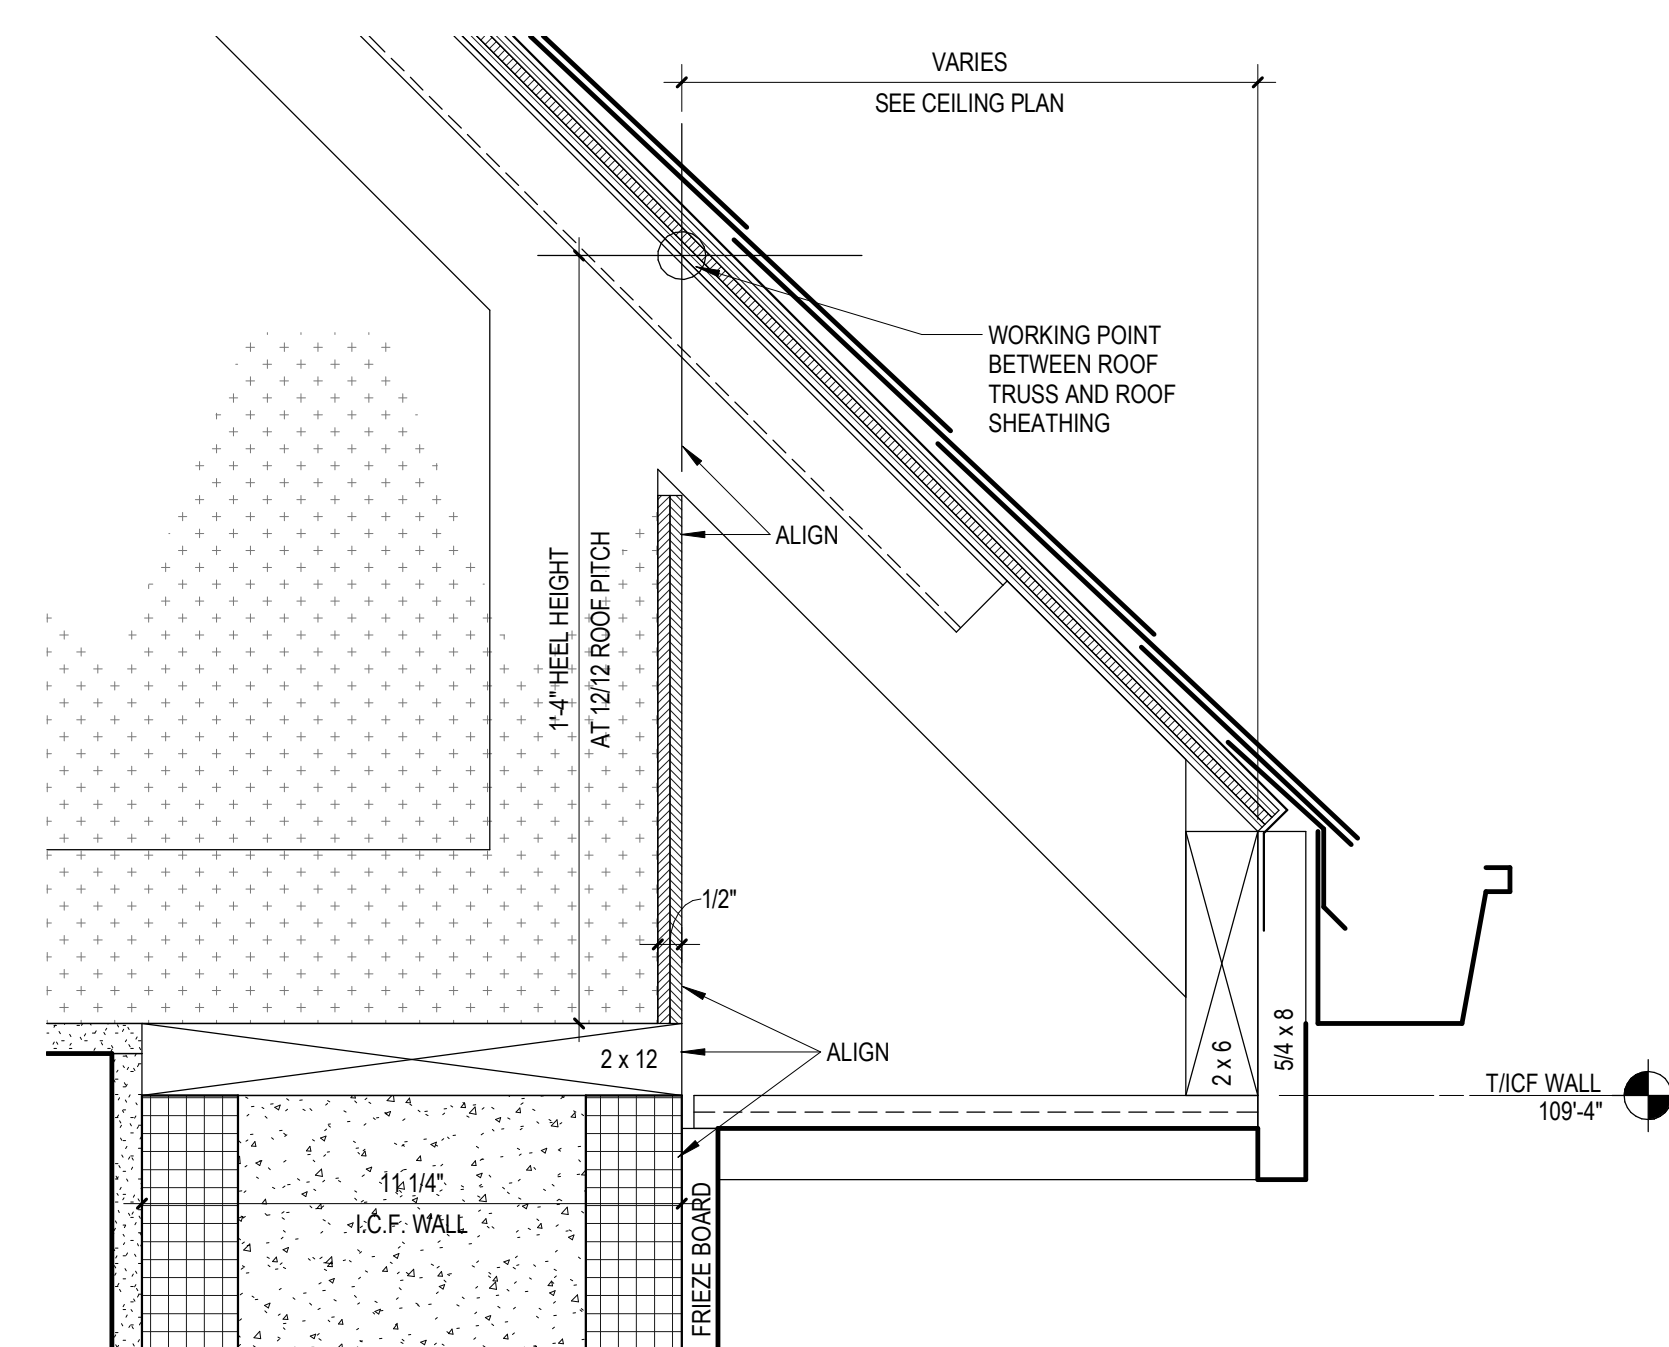


D7 12/12 EAVE DETAIL
3" = 1'-0"

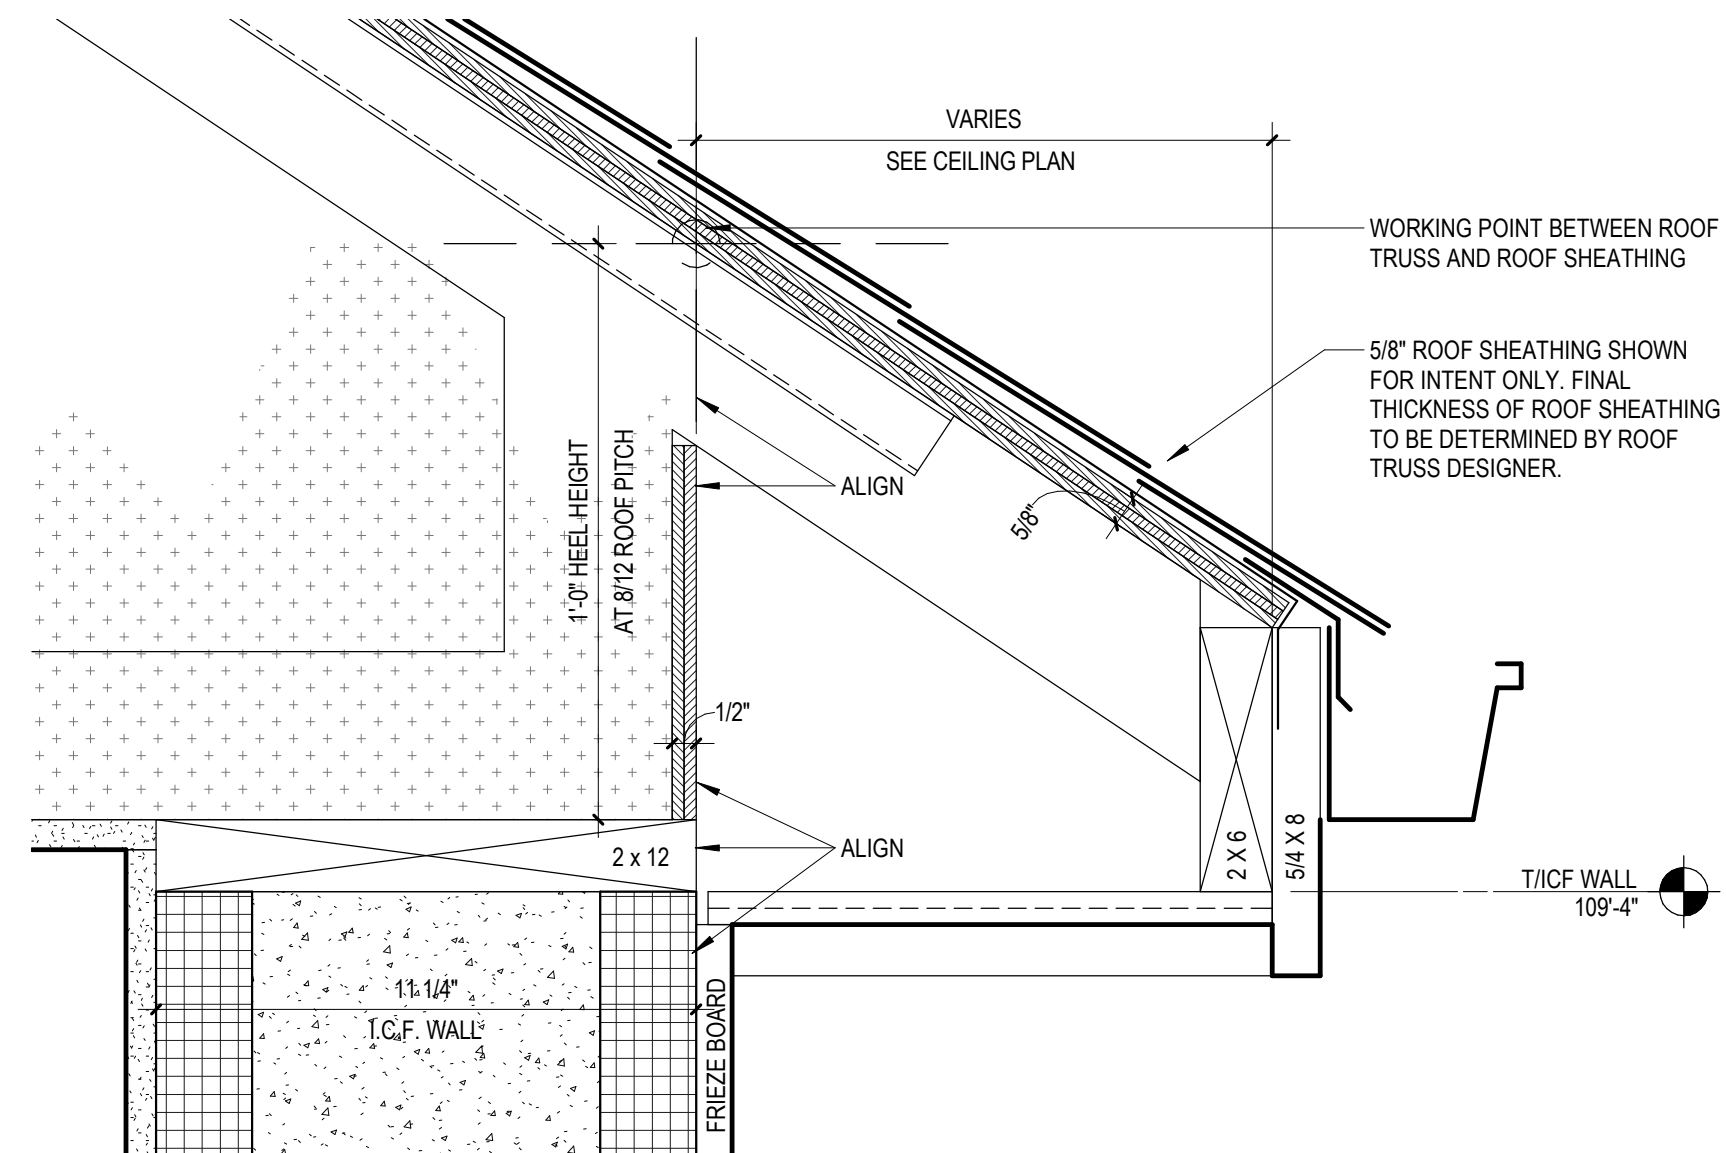


C7 8/12 EAVE DETAIL
3" = 1'-0"

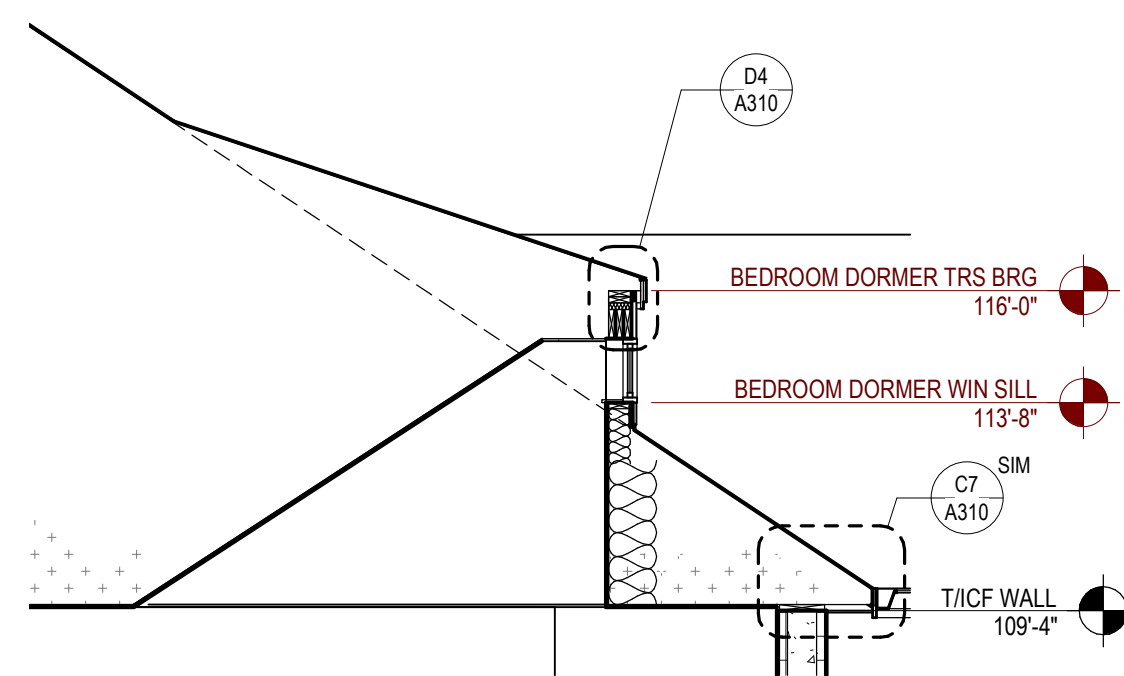


C3 BEDROOM DORMER SECTION
1/4" = 1'-0"

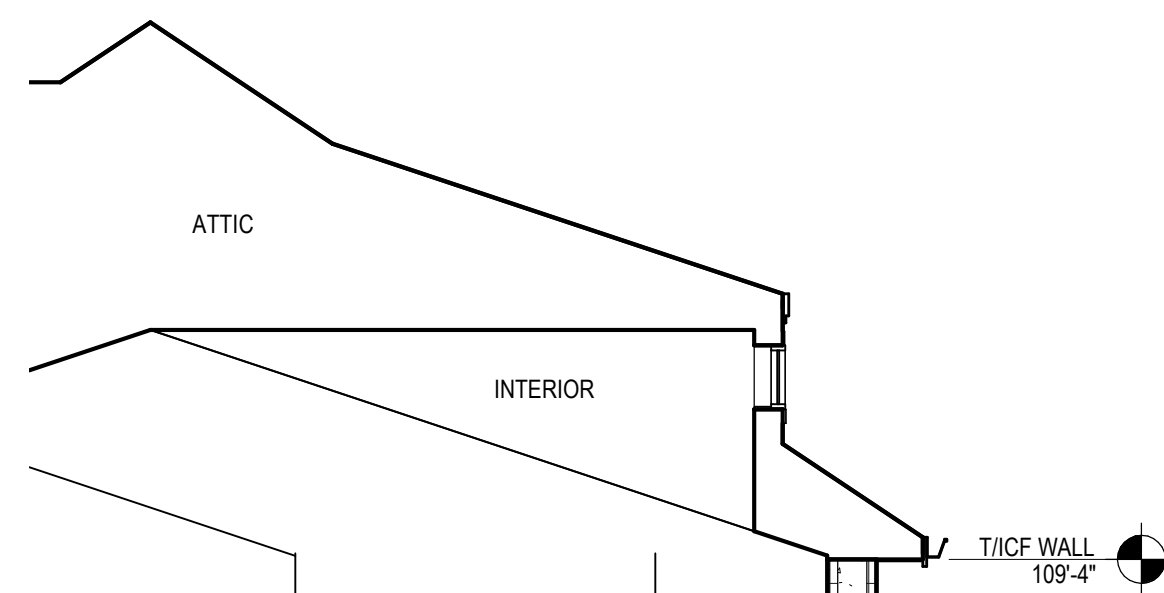


B2 KITCHEN DORMER SECTION
1/4" = 1'-0"

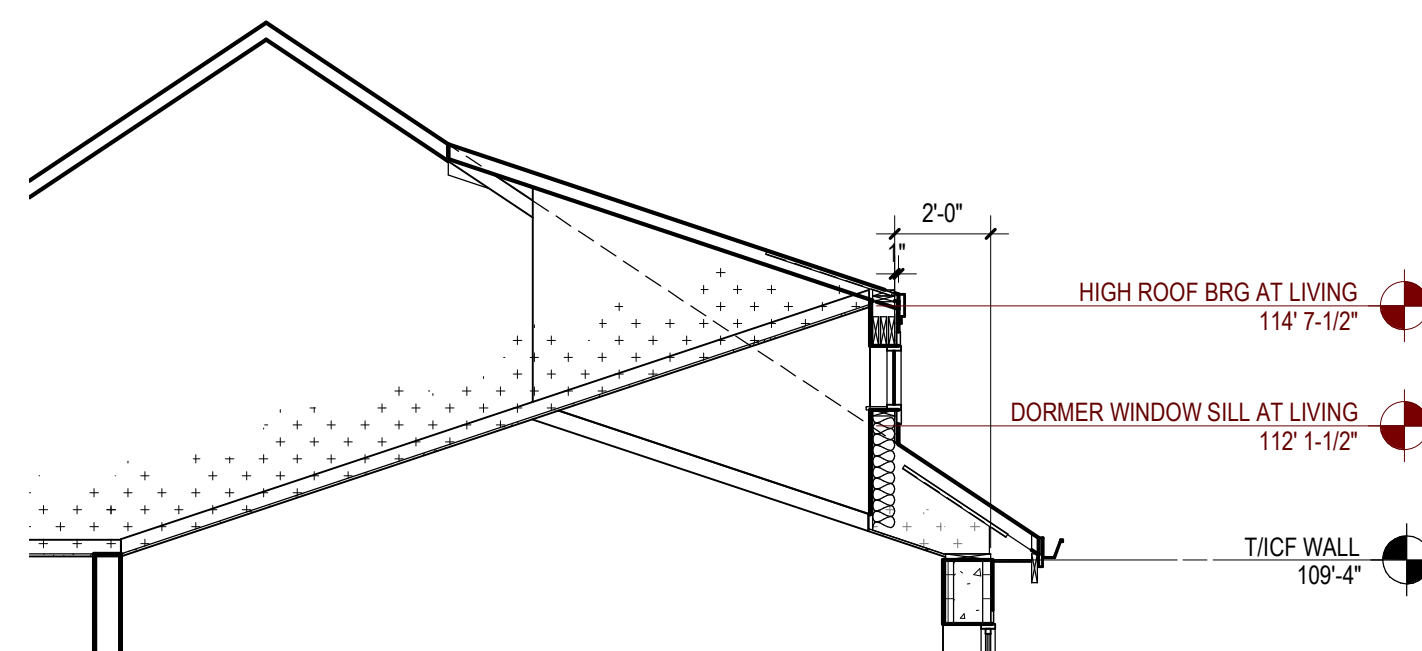


A2 LIVING ROOM DORMER SECTION
1/4" = 1'-0"

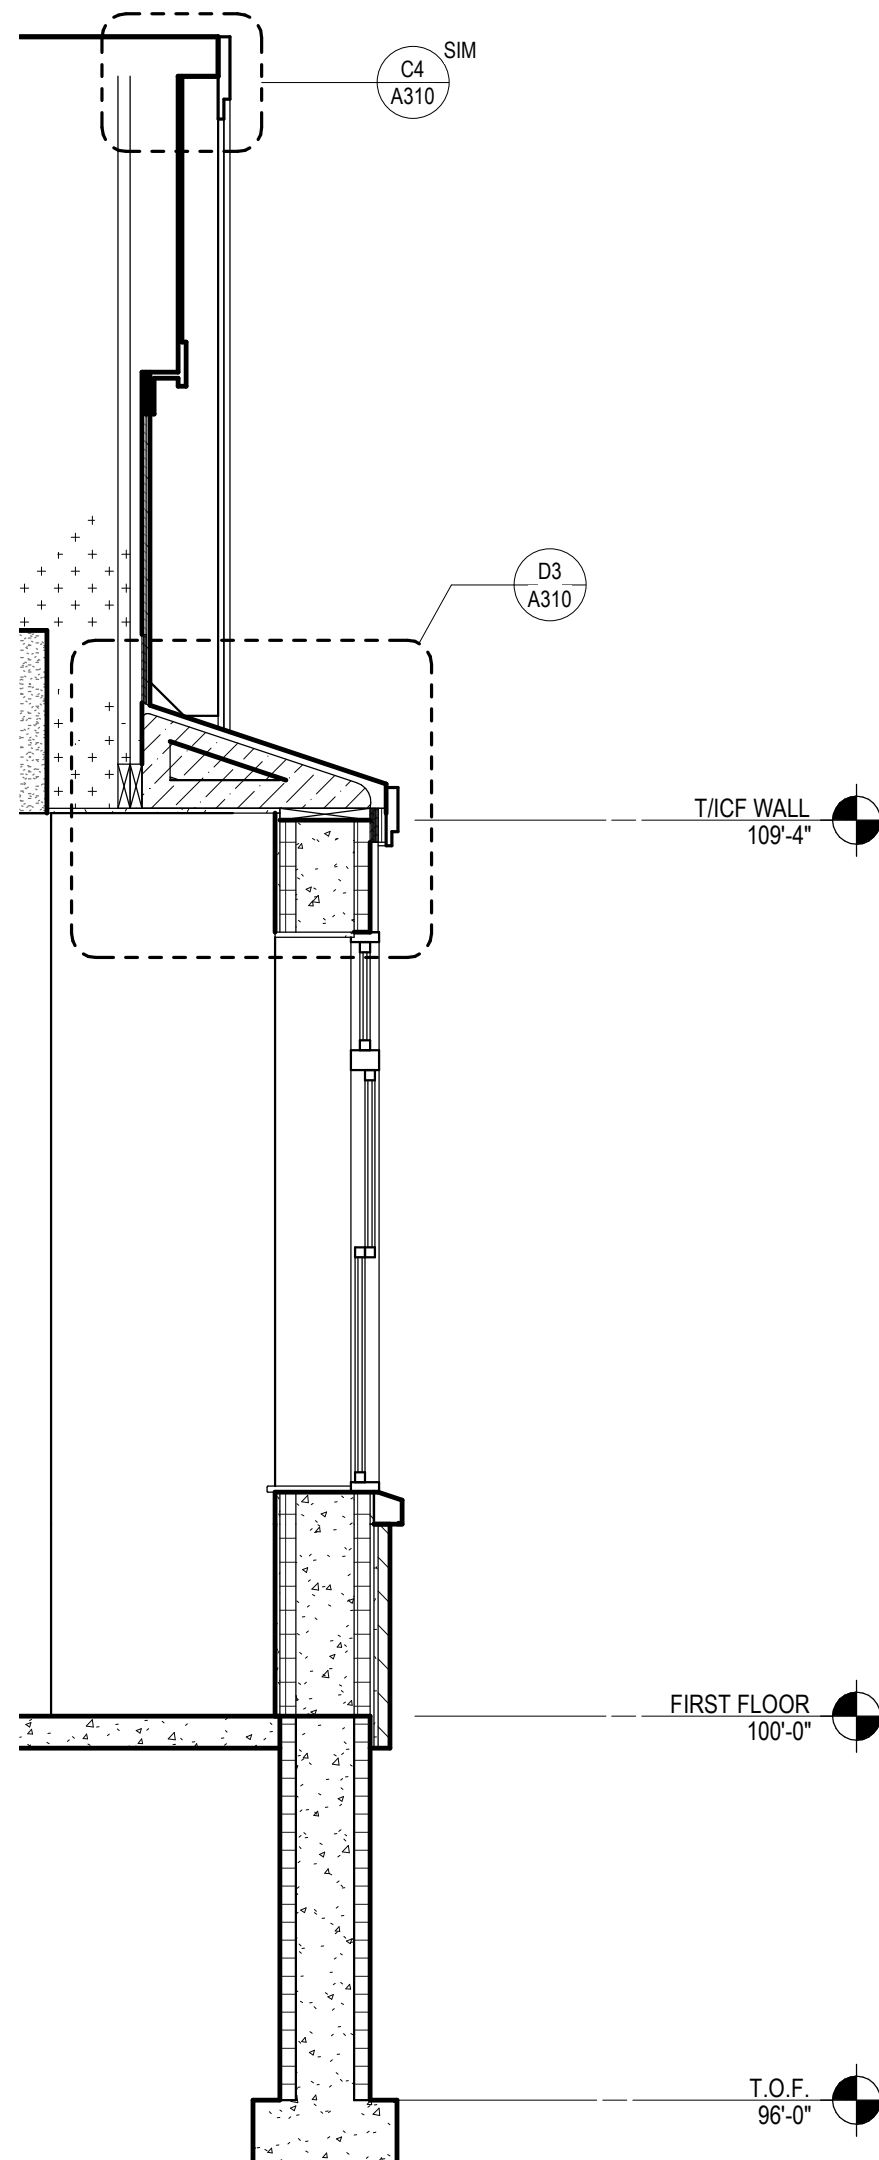

A4 WINDOW BAY SECTION
1/2" = 1'-0"

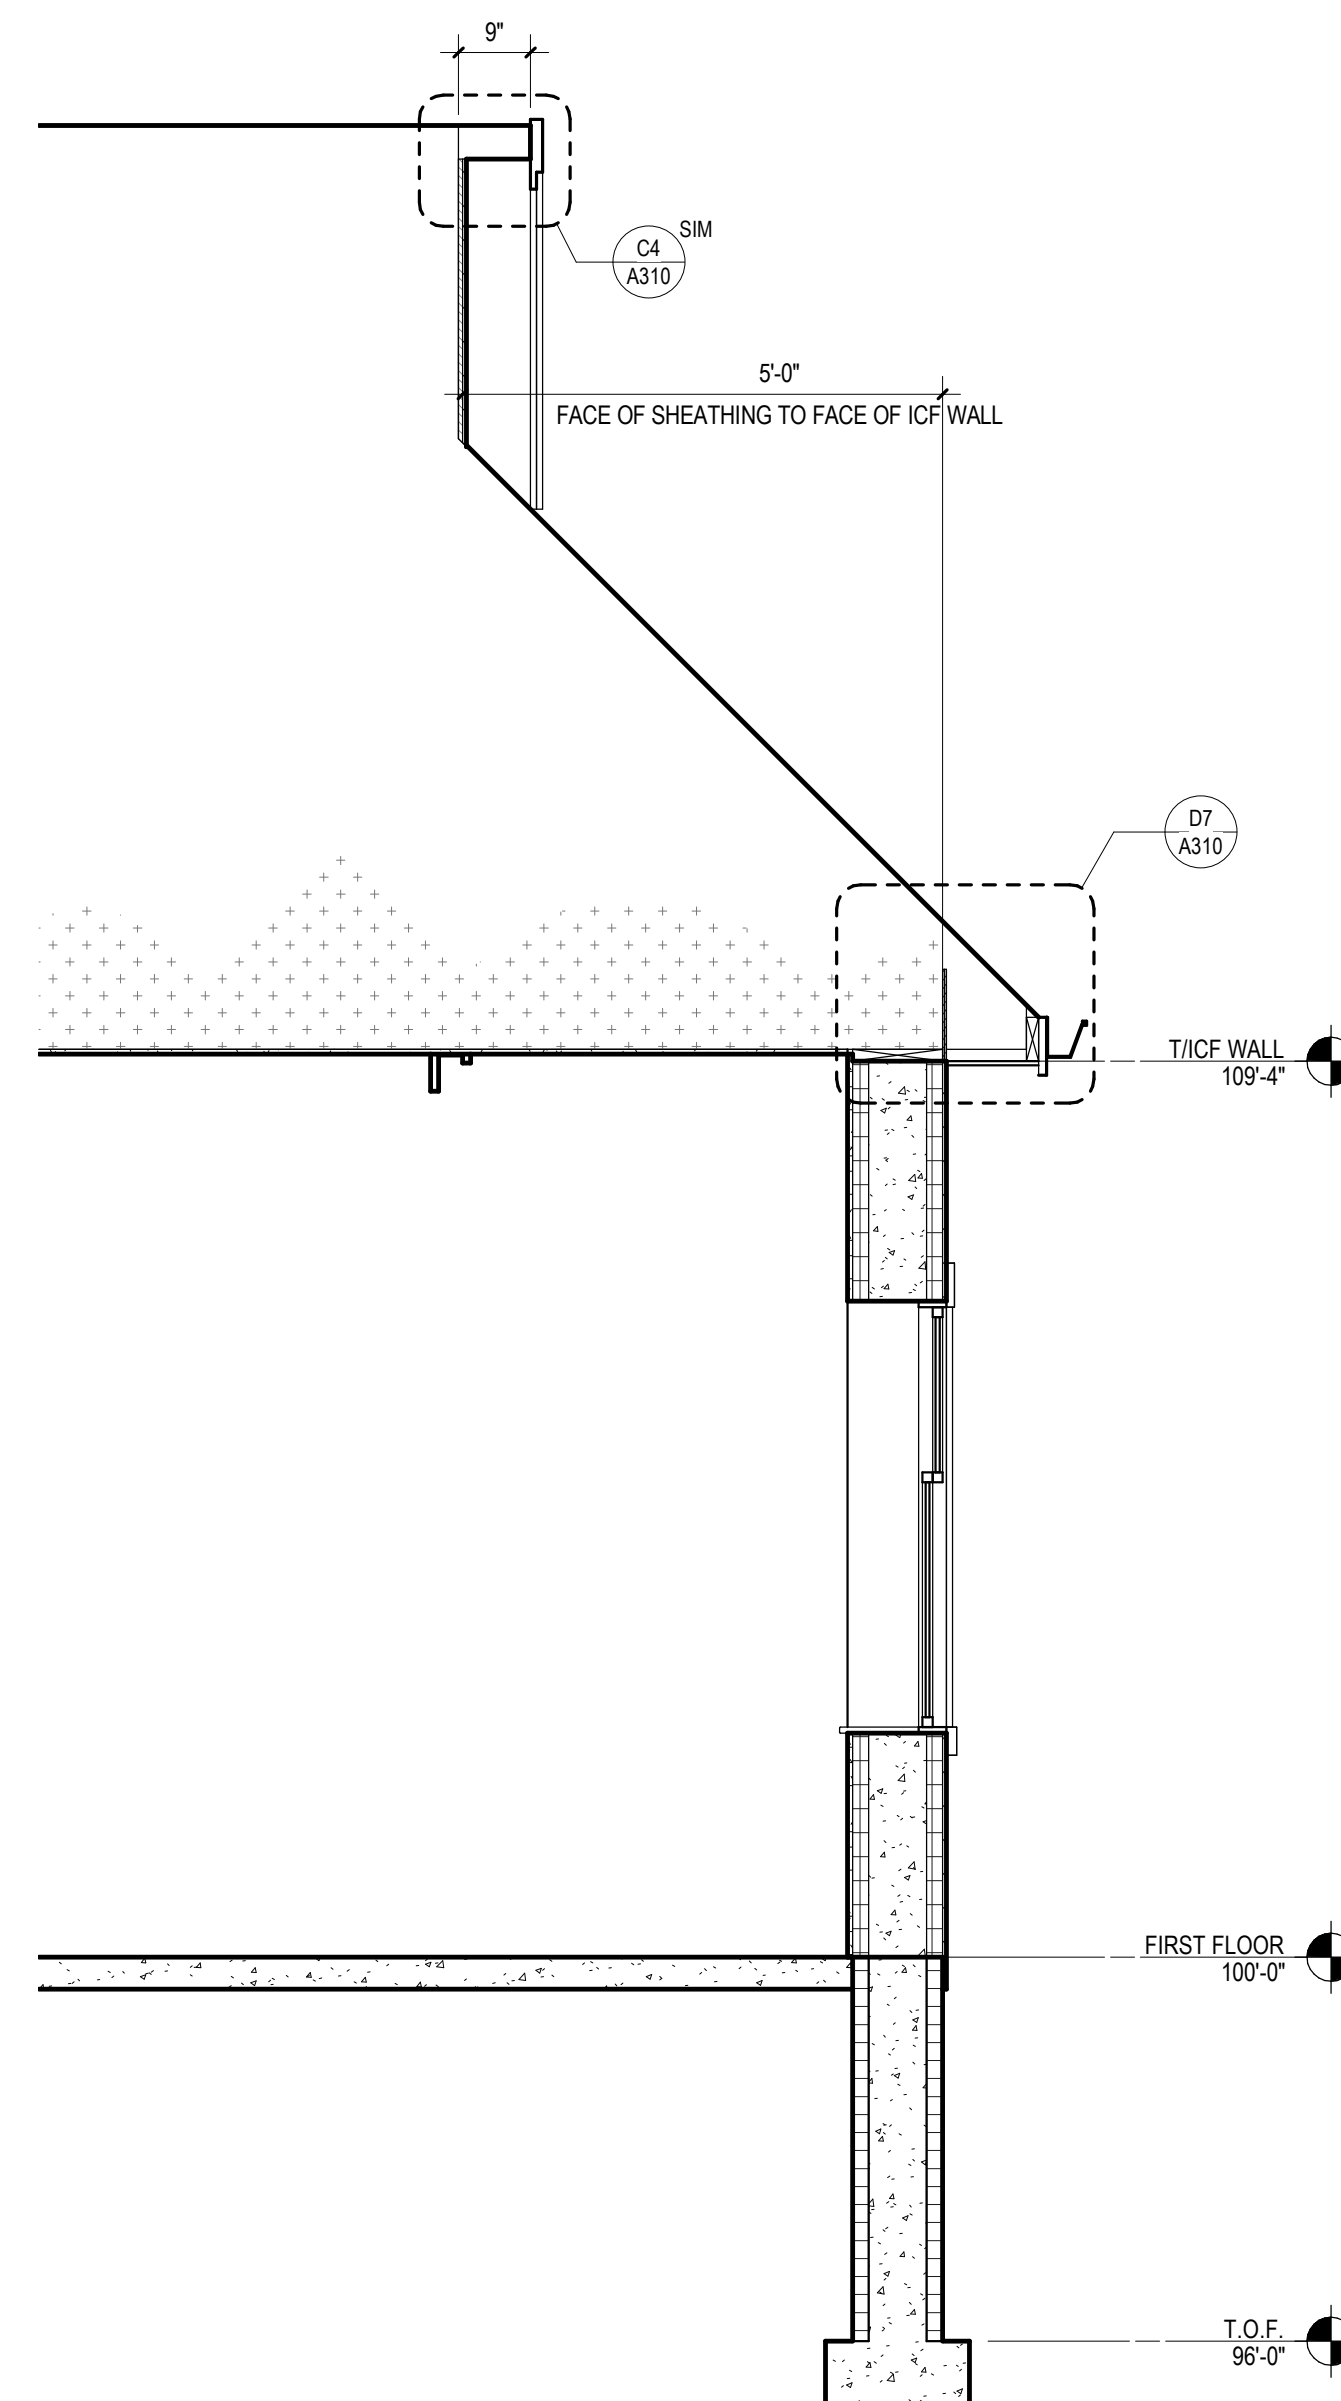

A6 12/12 WALL SECTION
1/2" = 1'-0"

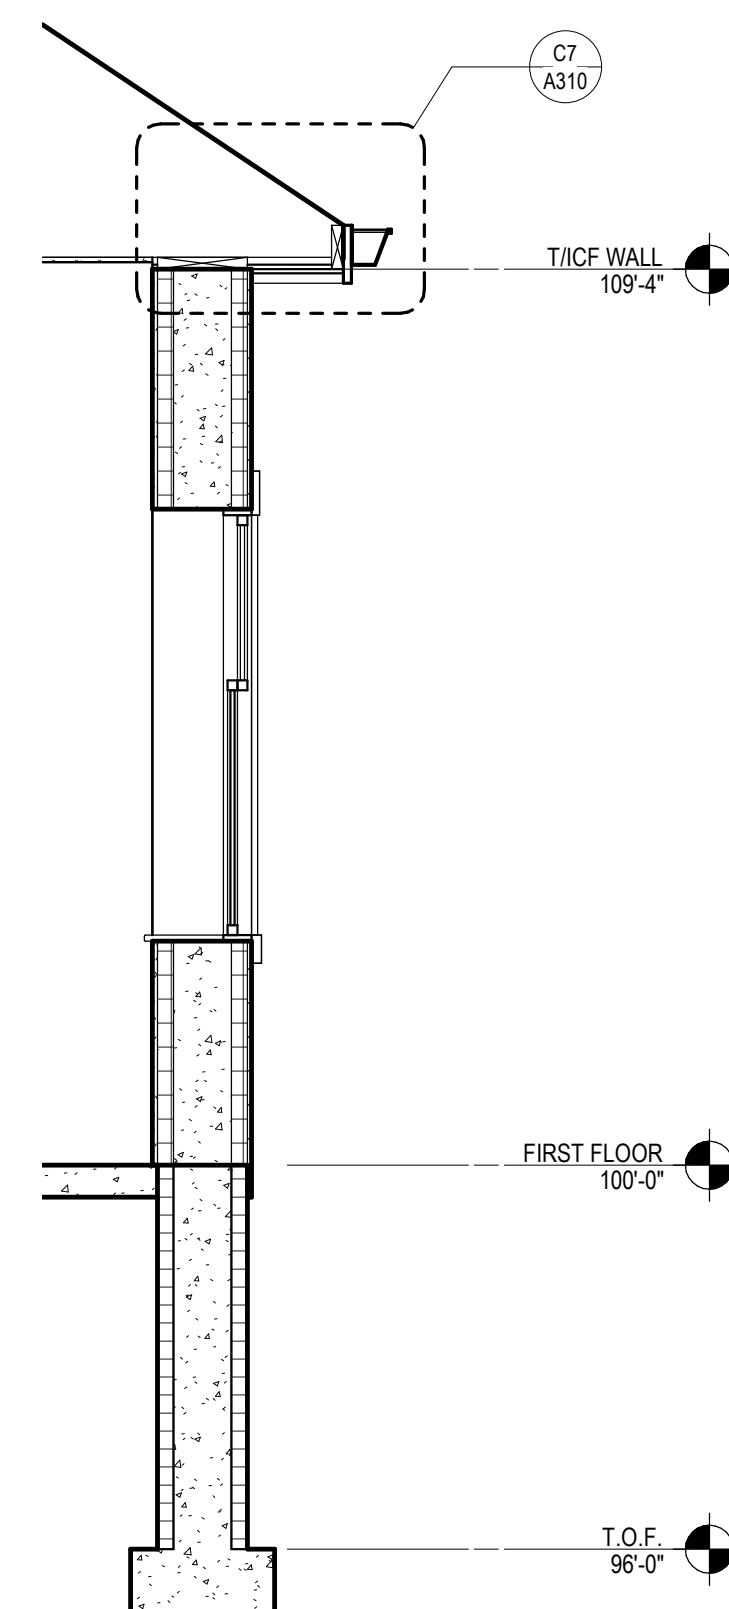

A7 8/12 WALL SECTION
1/2" = 1'-0"